



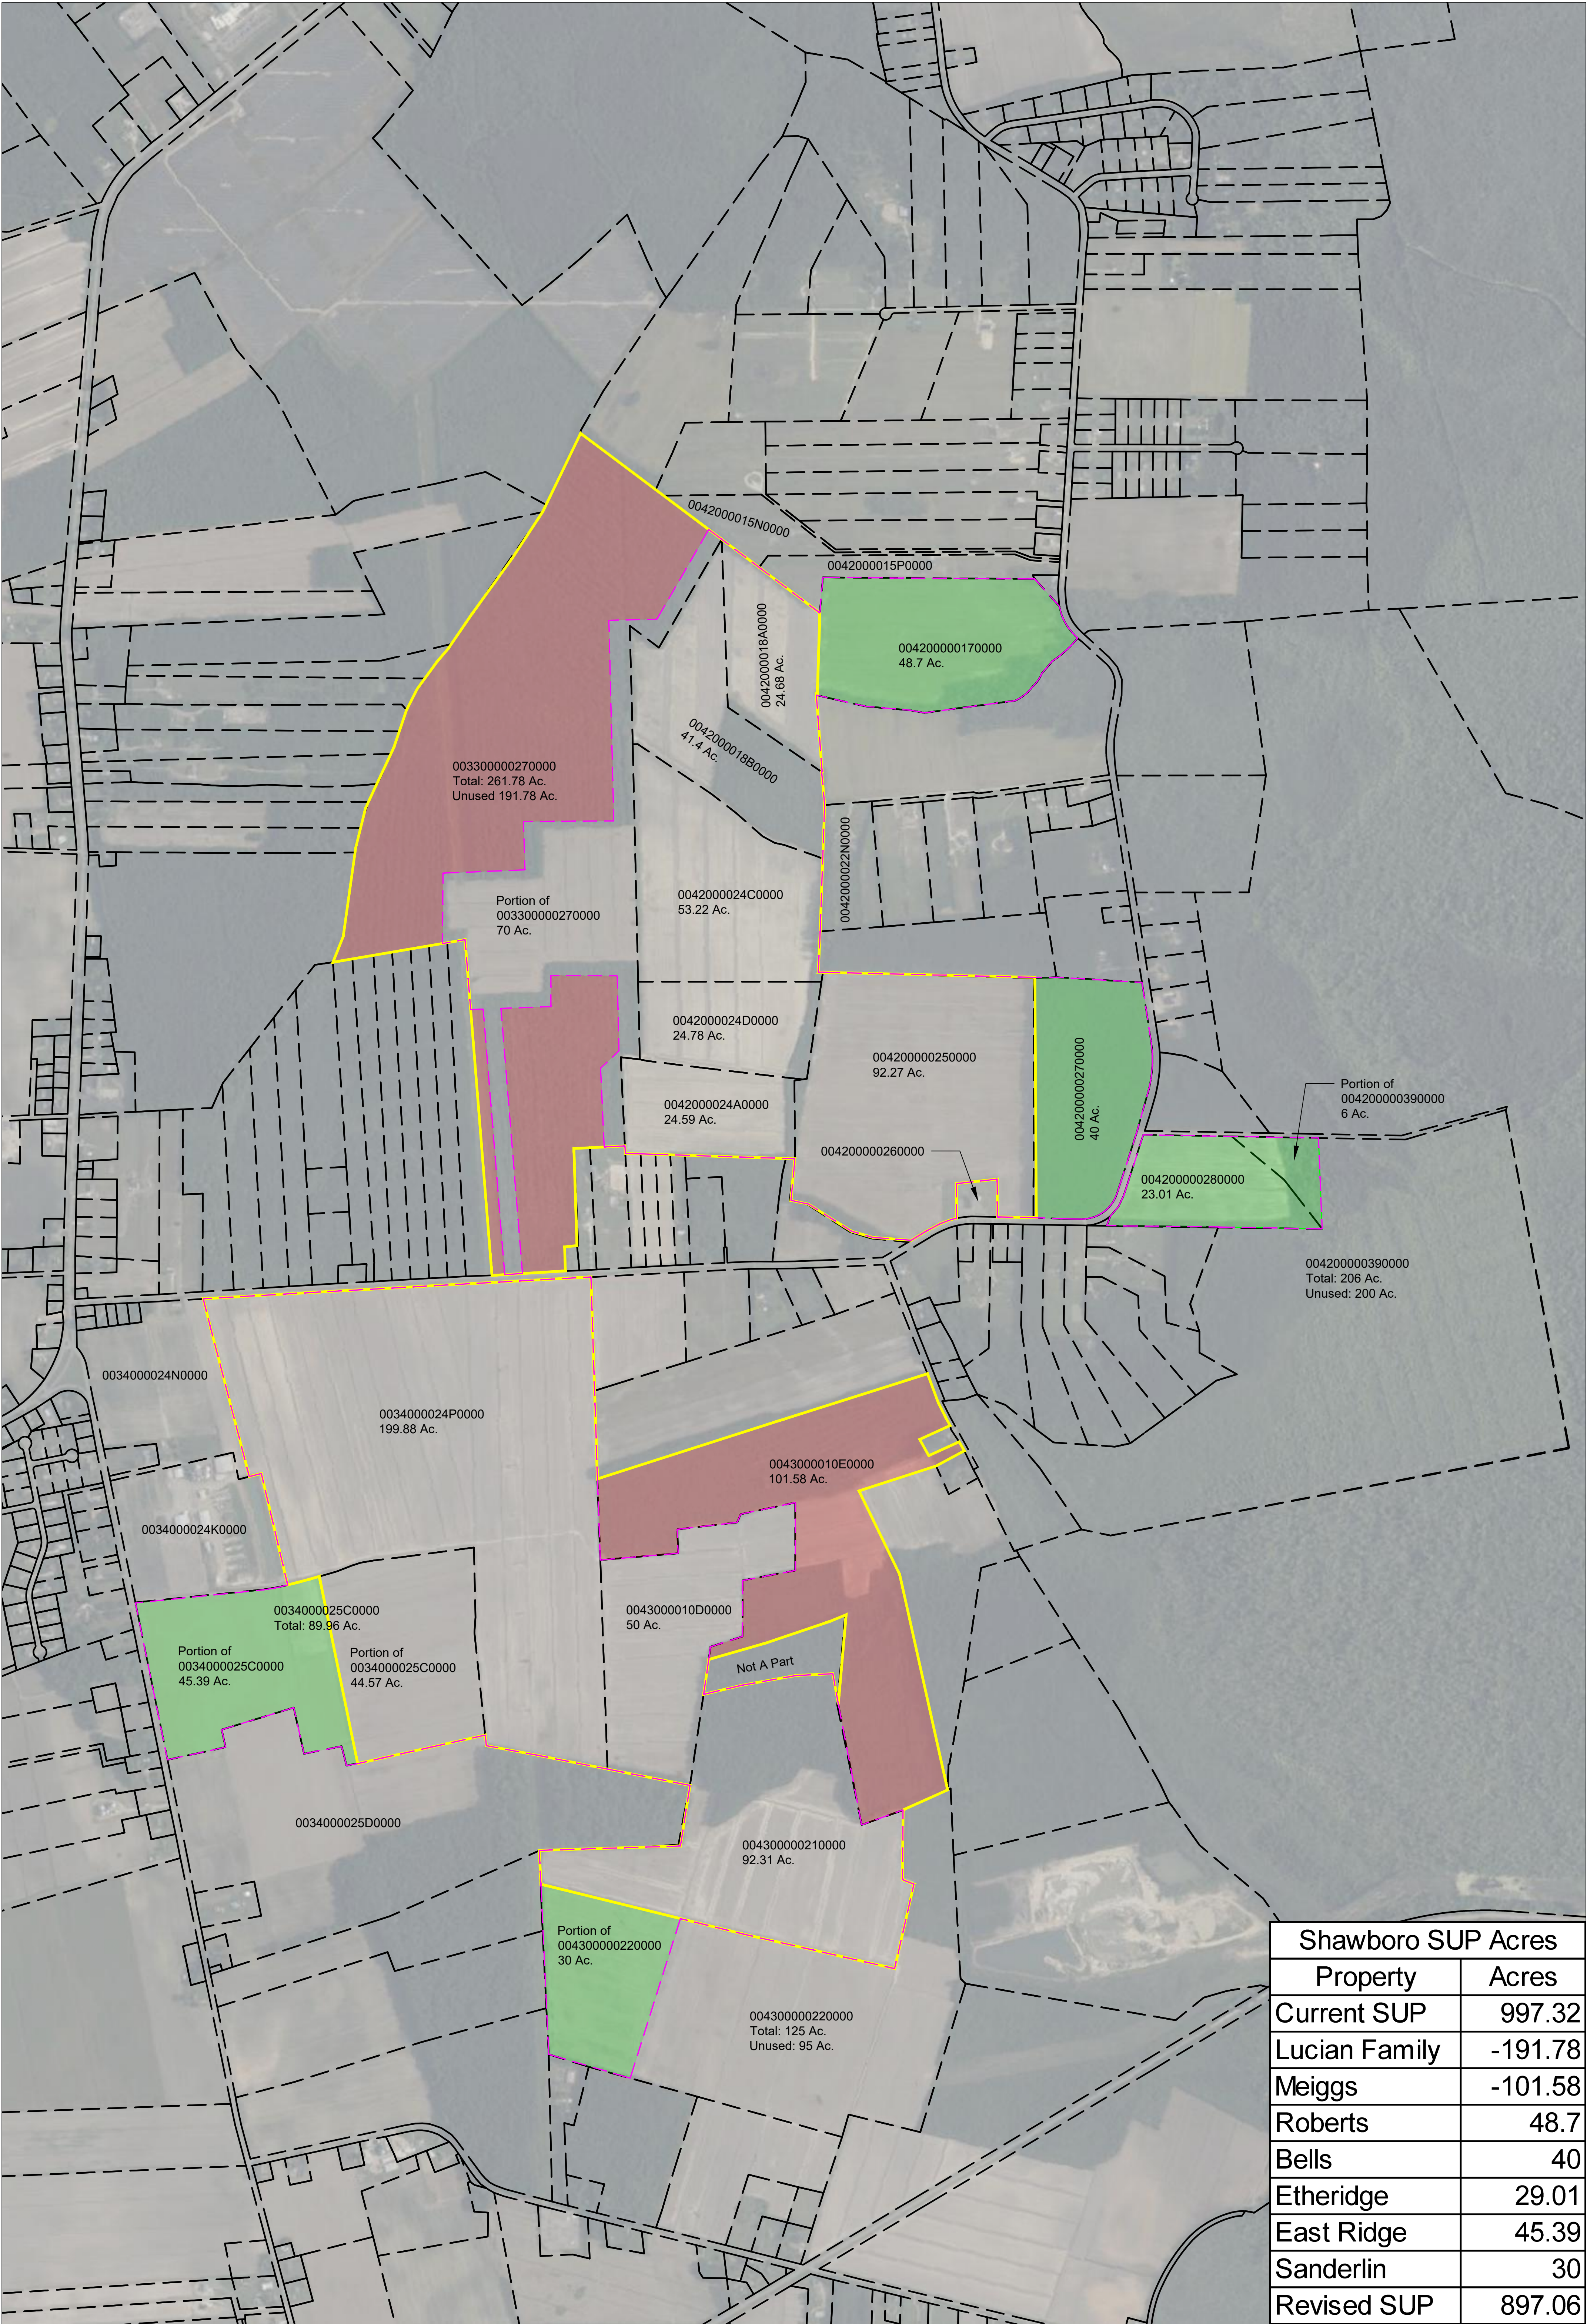


Shawboro SUP Acres	
Property	Acres
Current SUP	997.32
Lucian Family	-191.78
Meiggs	-101.58
Roberts	48.7
Bells	40
Etheridge	29.01
East Ridge	45.39
Sanderlin	30
Revised SUP	897.06

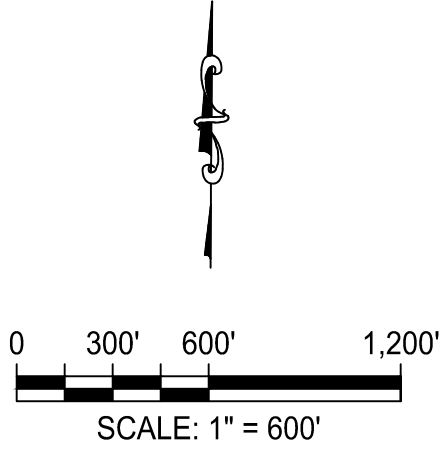


Shawboro East Ridge Solar SUP Amendment Exhibit


11/07/2025

SUP Project Boundary
GIS Property Lines
Current Project Property Line
Additional Tracts
Removed Tracts

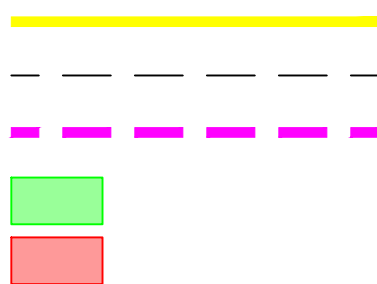

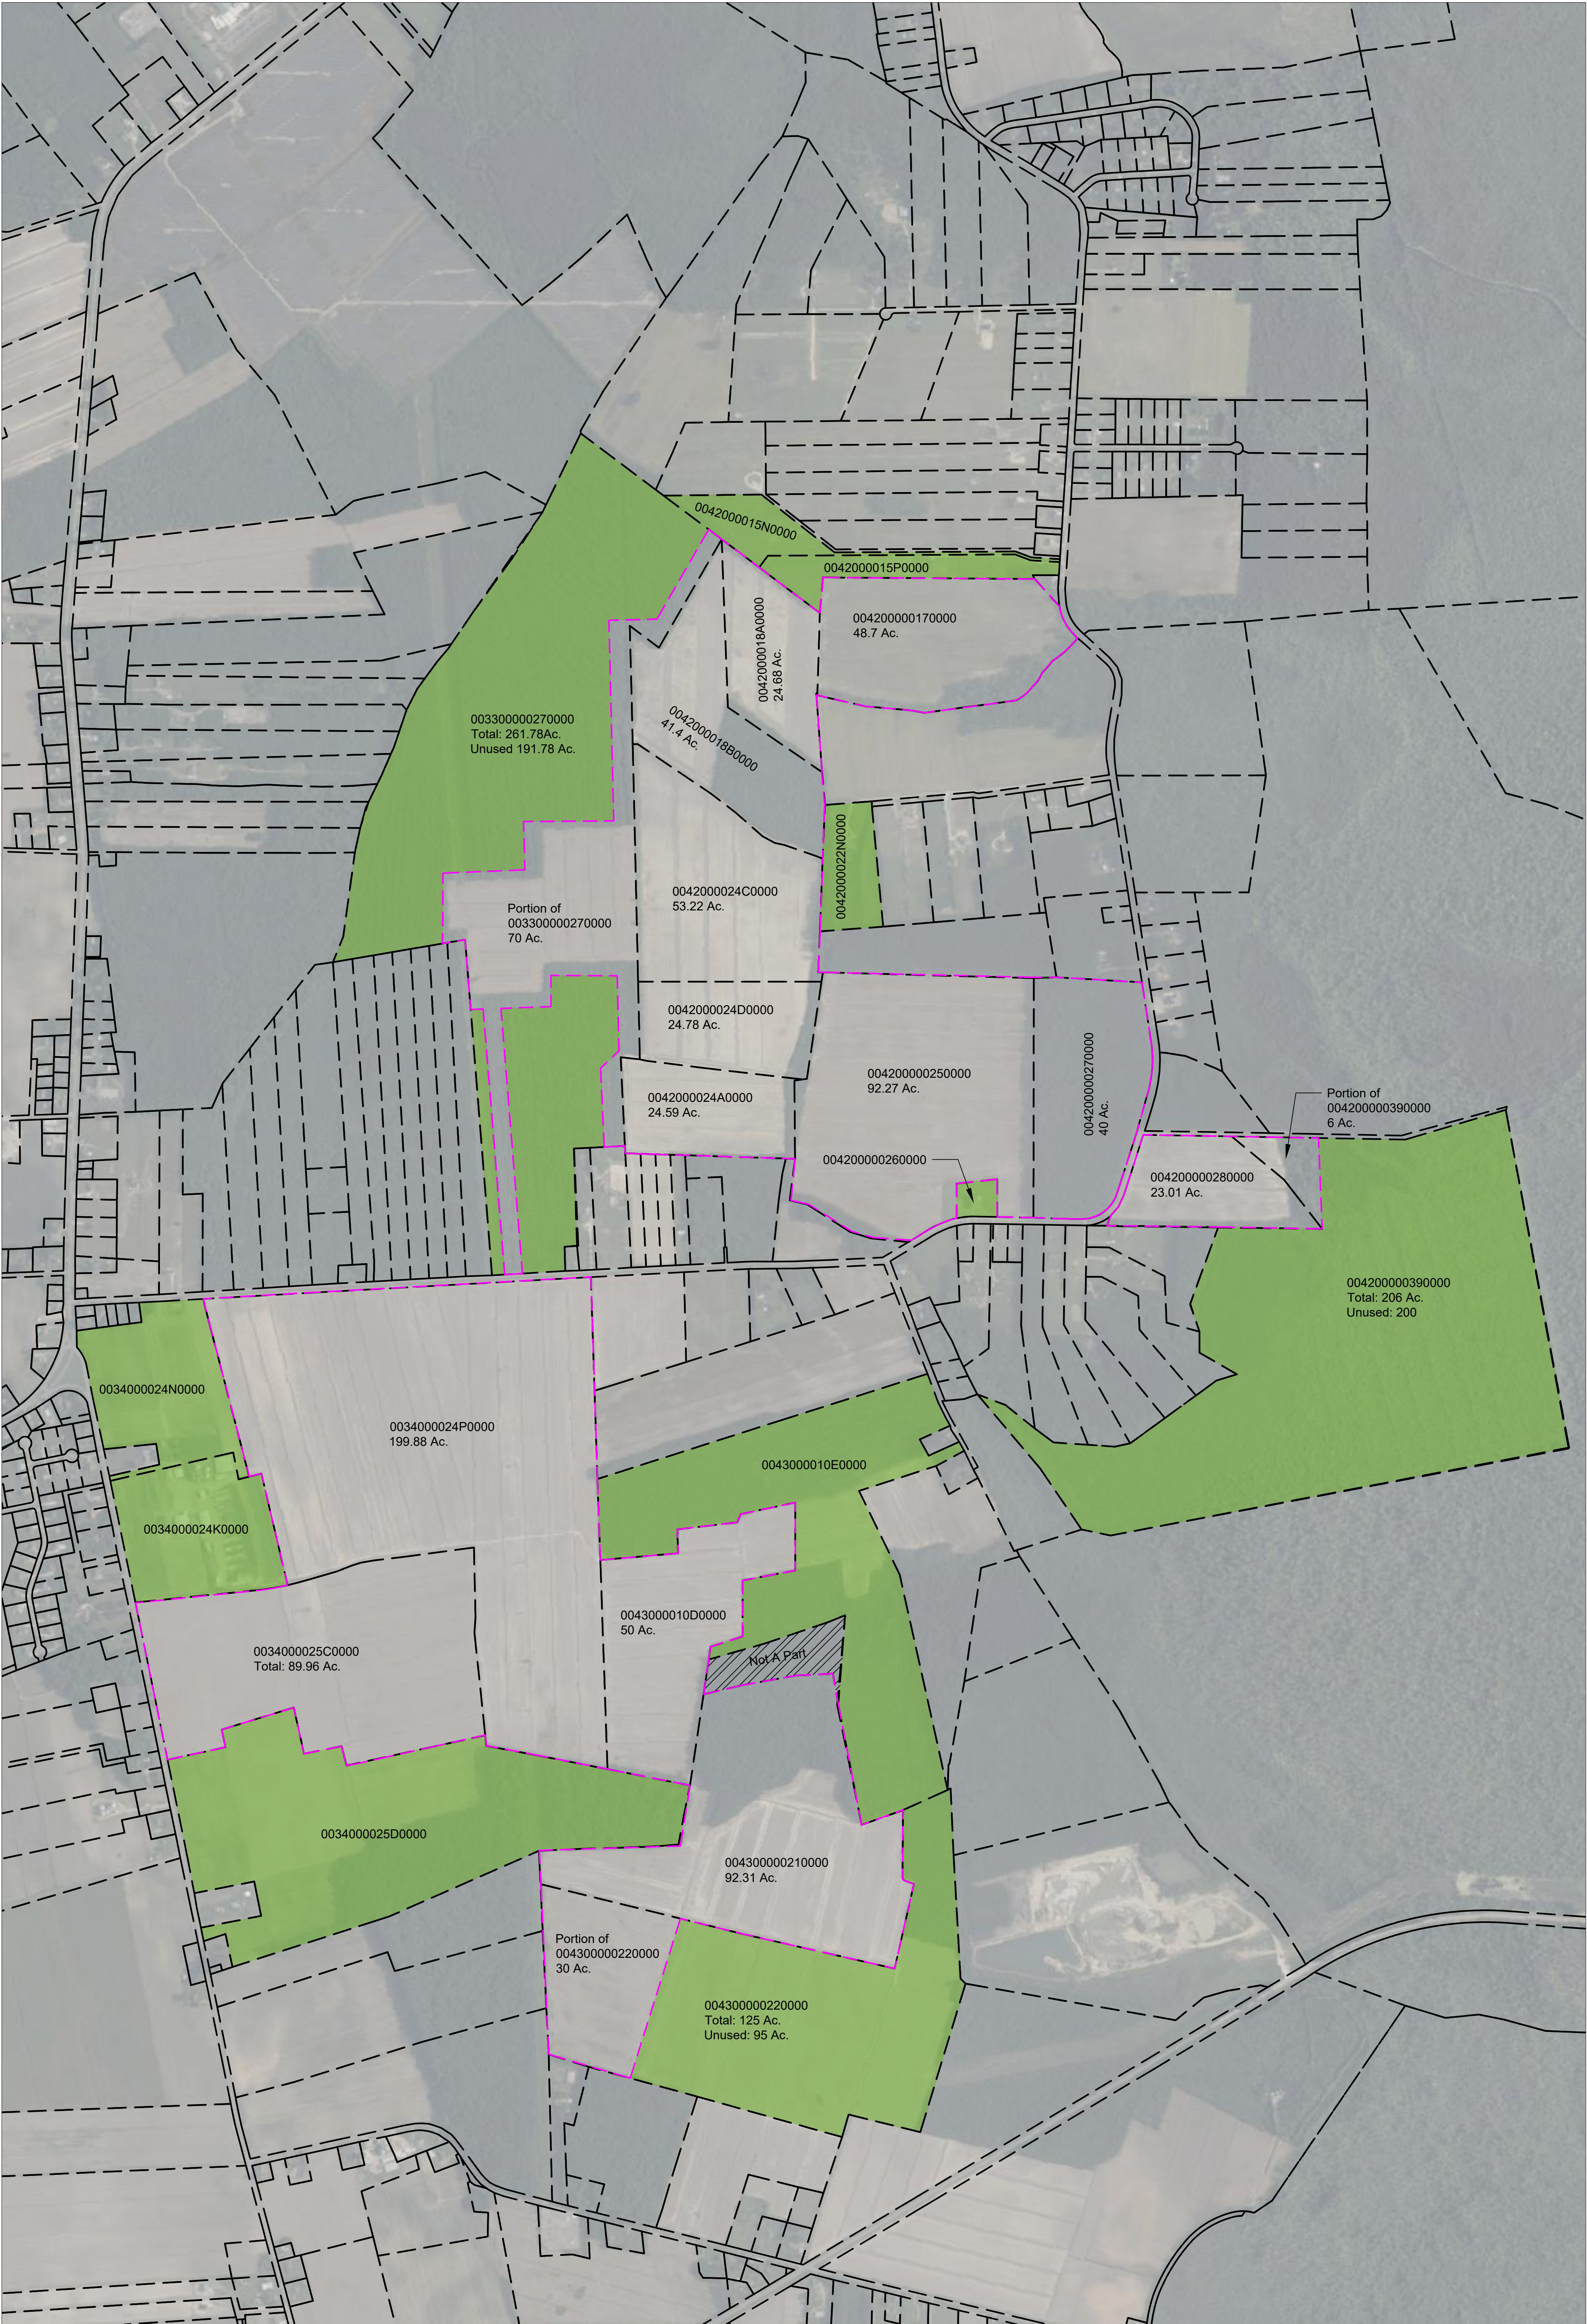

Shawboro East Ridge Solar Setback Waiver Property Exhibit

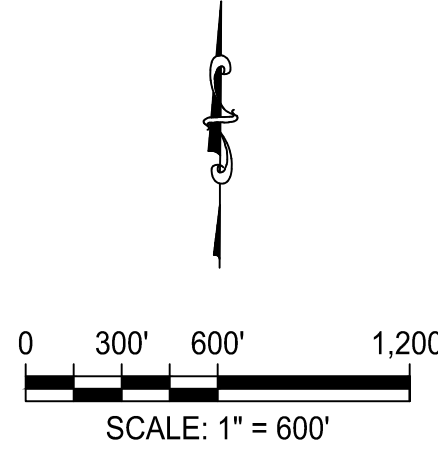

11/07/2025

- GIS Property Lines
- Current Project Property Line
- *Setback Waiver Properties

*Setback Waiver Properties are being added to the SUP for purposes of building to property lines. No equipment will be located on these parcels.



SHAWBORO EAST RIDGE SOLAR, LLC


SITE ADDRESS:
1021 EAST RIDGE RD
SHAWBORO, NC 27973

ORIGINAL SUP AREA: 997.32 897.06 AC
AMENDED SUP AREA: 897.06 AC

ZONING: AG (AGRICULTURAL)
EXISTING USE: VACANT / AGRICULTURAL
PROPOSED USE: SOLAR ENERGY FARM

LEGEND

- GIS PROPERTY LINE
- PROJECT BOUNDARY
- SET BACK WAIVER
- PROPERTY REMOVED WITH SETBACK WAIVER

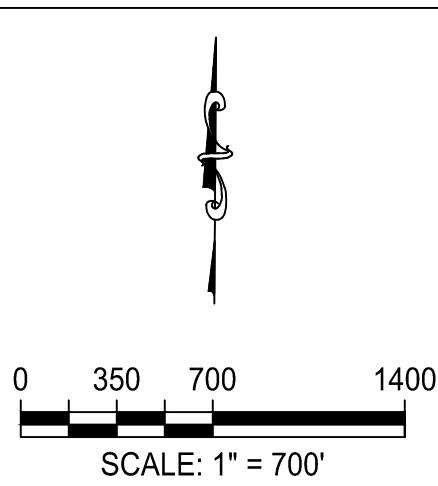

SUNENERGY1
595 Summer St, 4th Floor
Stamford, CT 06901
(203) 983-7875
www.SunEnergy1.com

NO.	DATE	DESCRIPTION	12	13	14	15	16	17	18	19	20
1	03/08/18	PROPERTY CHANGES	12/18/24	UPDATED ZONING SET							
2	01/31/18	PROPERTY CHANGES	01/26/24	UPDATED ZONING SET							
3	06/31/18	UPDATE LAYOUT	05/17/24	UPDATED ADDRESS PATHWAY TO REDUCE							
4	08/03/21	ADDED DETAILS PER COUNTY	02/05/24	UPDATED LAYOUT							
5	03/05/21	PROPERTY CHANGES	04/22/24	UPDATED SWITCHYARD AND SUBSTATION							
6	03/17/21	UPDATED LAYOUT	01/24/25	UPDATED LAYOUT							
7	03/22/21	REMOVED EASTERN PROPERTY	02/10/25	UPDATED ZONING SET							
8	06/01/21	UPDATED LAYOUT AND REMOVED PROPERTY ON N. INDIAN TOWN RD	01/07/25	UPDATED ZONING SET							
9	04/22/22	UPDATED LAYOUT									
10	09/16/22	EXISTING VEGETATION SUBSTITUTION									
11	06/22/22	UPDATED ZONING SET									

PROJECT NAME
SHAWBORO EAST RIDGE SOLAR
PV POWER PLANT
IN SHAWBORO, NORTH CAROLINA

CHECKED
DS

DRAWN
CJM

JOB NO.
AE1-072

LATEST REVISION
07 NOV 2025

PROPERTY INFORMATION

DRAWING NO.
SL1.0

PIN IDs	Property Owner's Name	Address	Telephone	Email Address	Acreage	Land Control	Zoning Classification	Deed Book-Page Number
003300000270000	Lucian Family, LLC	PO Box 237 Powells Point, NC 27966	252-202-3450	griffinobx@gmail.com	261.78	GL	AG	831-147
004200000250000	East Ridge Land Holdings (Previously Nancy Ann Ferebee)	595 Summer St, 4th Floor Stamford CT 06901 Attn: Legal Department	203-825-1731	legal@sunenergy1.com	90.16	GL	AG	1791-767
0042000018A0000 0042000018B0000	East Ridge Land Holdings (Previously Garry L. John & Deborah C. John)	595 Summer St, 4th Floor Stamford CT 06901 Attn: Legal Department	203-825-1731	legal@sunenergy1.com	24.68 41.4	GL	AG	1793-597
00340000025C0000	East Ridge Land Holdings (Previously Lantz, James Henry	P.O Box 11 Shawboro, NC 27973	203-825-1731	legal@sunenergy1.com	89.96	GL	AG	1822-635
0042000024C0000 (Previously 0042000024B0000)	East Ridge Land Holdings (Previously James Owen Etheridge, Lela Ann Etheridge, Joseph Doc Etheridge, Jane Etheridge-Small	595 Summer St, 4th Floor Stamford CT 06901 Attn: Legal Department	203-825-1731	legal@sunenergy1.com	53.22	GL	AG	1800-145
0042000024A0000	East Ridge Land Holdings (Previously Etheridge, Doc Horace JR)	595 Summer St, 4th Floor Stamford CT 06901 Attn: Legal Department	203-825-1731	legal@sunenergy1.com	24.64	GL	AG	1219-590
00340000024P0000 (Previously 00340000024L0000 (portion))	East Ridge Land Holdings (Previously Nancy A. Ferebee & James H. Ferebee, Jr.)	595 Summer St, 4th Floor Stamford CT 06901 Attn: Legal Department	203-825-1731	legal@sunenergy1.com	199.88	GL	AG	1791-767
004300000210000	East Ridge Land Holdings (Previously Indian Ridge Properties, LLC)	595 Summer St, 4th Floor Stamford CT 06901 Attn: Legal Department	203-825-1731	legal@sunenergy1.com	91.59	GL	AG	1791-767
00430000010D0000 (Previously 004300000010B0000	East Ridge Land Holdings (Previously Stanley H. Meiggs & Jeanne E. Meiggs)	595 Summer St, 4th Floor Stamford CT 06901 Attn: Legal Department	203-825-1731	legal@sunenergy1.com	151.58	GL	AG	
00420000024A0000	Owen Etheridge Lela Ann Etheridge Joe Doc Etheridge Jane Etheridge-Small	882 Shawboro RD Shawboro, NC 27973	757-880-0121 252-455-0586 615-297-2620 804-625-2294	mapleKnollFarms@gmail.com currituckcommish@gmail.com laetheridge@hotmail.com jane_etheridge1@yahoo.com	24.64	OTL	AG	1219-590
00420000024D0000	Owen Etheridge Lela Ann Etheridge Joe Doc Etheridge Jane Etheridge-Small	882 Shawboro RD SHAWBORO, NC 27973	757-880-0121 252-455-0586 615-297-2620 804-625-2294	mapleKnollFarms@gmail.com currituckcommish@gmail.com laetheridge@hotmail.com jane_etheridge1@yahoo.com	25.43	OTL	AG	1799-614

Exhibit B (Additional Land)

PIN IDs	Property Owner's Name	Address	Telephone	Email Address	Acreage	Land Control	Zoning Classification	Deed Book-Page Number
004200000270000	Robert F Bell, Jr Ann M Bell Margaret Radintz	PO BOX 144 Shawboro, NC 27973	252-455-7618	N/A	40	OTP	AG	1305-285
004200000280000	Owen Etheridge Lela Ann Etheridge Joe Doc Etheridge Jane Etheridge-Small	882 Shawboro RD SHAWBORO, NC 27973	757-880-0121 252-455-0586 615-297-2620 804-625-2294	mapleKnollFarms@gmail.com currituckcommish@gmail.com laetheridge@hotmail.com jane_etheridge1@yahoo.com	23.01	OTL	AG	227-360
004200000390000	Owen Etheridge Lela Ann Etheridge Joe Doc Etheridge Jane Etheridge-Small	882 Shawboro RD Shawboro, NC 27973	757-880-0121 252-455-0586 615-297-2620 804-625-2294	mapleKnollFarms@gmail.com currituckcommish@gmail.com laetheridge@hotmail.com jane_etheridge1@yahoo.com	206 (Only Using 6 acres)	OTL	AG	227-360
004200000170000	Sandra C Roberts	650 Snowden Road Moyock, NC 27958	252-232-3459	N/A	48.7	OTL	AG	108-514
004300000220000	Joyce and James Duncan Rebecca Sanderlin Harold Sanderlin Tracey Sparkman Rhonda Curling Lauren Bumann	1296 Shortcut Rd Shawboro, NC 27973	(252) 336-4886, (252) 336-4363, (252) 232-3303, (817) 706-1492, (757) 270-6069, (252) 339-7484	hssanderlin@yahoo.com; tbotello@hotmail.com; r.curling9@gmail.com; lauren.bumann@gmail.com	125	OTP	AG	313-589

Exhibit C (Adjacent Land)

PIN IDs	Property Owner's Name	Address	Telephone	Email Address	Acreage	Land Control	Zoning Classification	Deed Book-Page Number
00430000010E0000	Meiggs, Stanley & Jeanne	1693 Tulls Creek Rd Moyock, NC 27958	(252) 256-2394	N/A	101.58	N/A	AG	24/E/001189
00340000024K0000	Ferebee, James and Joel	134 Waters Drive Moyock, NC 27957	(252) 202-1392	Nancy.ferebee@gmail.com	31.88	N/A	AG	1150/186
00340000024N0000	Ferebee, Nancy and Jim	134 Waters Drive Moyock, NC 27958	(252) 202-1392	Nancy.ferebee@gmail.com	32.24	N/A	AG	16/E/160
00340000025D0000	Forbes, Joseph	PO BOX 3 SHAWBORO, NC 27973	(252) 331-9002	N/A	115.47	N/A	AG	20/E/153
0042000015P0000	McCroskey, Ronald and Kathryn	600 EAST RIDGE RD SHAWBORO, NC 27973	360-731-0901	N/A	12.05	N/A	AG	1656/302
0042000022N0000	McKay, Derek and Heather	113 AMY LANDING RD SHAWBORO, NC 27973	619-994-8024	derekmckay@y7mail.com	11.45	N/A	AG	1561/126
420000260000	New Providence Baptist Church	876 EAST RIDGE RD SHAWBORO, NC 27973	(252) 232-3250	N/A	2.88	N/A	AG	625/210
0042000015N0000	Soriano, Rex and Marygrace	4104 MARBLEHEAD DR VIRGINIA BEACH, VA 23453	757-509-1333	Rex.R.Soriano@gmail.com	10.93	N/A	AG	1709/158

Exhibit D (Removed Land)

PIN IDs	Property Owner's Name	Address	Telephone	Email Address	Acreage	Land Control	Zoning Classification	Deed Book-Page Number
00430000010E0000 (Previously 00430000010B0000) (portion)	Stanley H. Meiggs & Jeanne E. Meiggs	1693 Tulls Creek Road Moyock, NC 27958	(252) 256-2394	N/A	101.58	N/A	AG	24/E/001189
0033000000270000 (portion)	Lucian Family, LLC	PO Box 237 Powells Point, NC 27966	252-202-3450	griffinobx@gmail.com	261.78	N/A	AG	831-147



595 Summer St, 4th Floor
Stamford, CT 06901
(203) 983-7875
www.SunEnergy1.com

PROJECT NAME

SHAWBORO EAST
RIDGE SOLAR
PV POWER PLANT
IN SHAWBORO, NORTH CAROLINA

PROJECT NO.

AE1-072

LATEST REVISION

07 NOV 2025

DATE

DESCRIPTION

1

03/08/18

PROPERTY CHANGES

2

01/31/18

PROPERTY CHANGES

3

06/31/18

UPDATE LAYOUT

4

03/03/21

ADDED DETAILS PER COUNTY

5

03/05/21

PROPERTY CHANGES

6

03/17/21

UPDATED LAYOUT

7

03/22/21

REMOVED EASTERN PROPERTY

8

06/01/21

UPDATED LAYOUT AND REMOVED PROPERTY ON N. MOUNTAIN RD.

9

04/22/22

UPDATED LAYOUT

10

09/16/22

EXISTING VEGETATION SUBSTITUTION

11

06/22/22

UPDATED ZONING SET

12

11/03/24

UPDATED ZONING SET

13A

01/28/24

UPDATED ZONING SET

13

05/17/24

UPDATED ADDRESS PATHWAY TO REDUCE

14

02/05/24

UPDATED LAYOUT

15

06/12/24

UPDATED SWITCHYARD AND SUBSTATION

16

01/24/25

UPDATED LAYOUT

17

02/10/25

UPDATED LAYOUT

18

04/07/25

UPDATED ZONING SET

19

11/07/25


UPDATED ZONING SET

DRAWING TITLE

PROPERTY OWNER
CONTACTS

DRAWING NO.


SL1.1

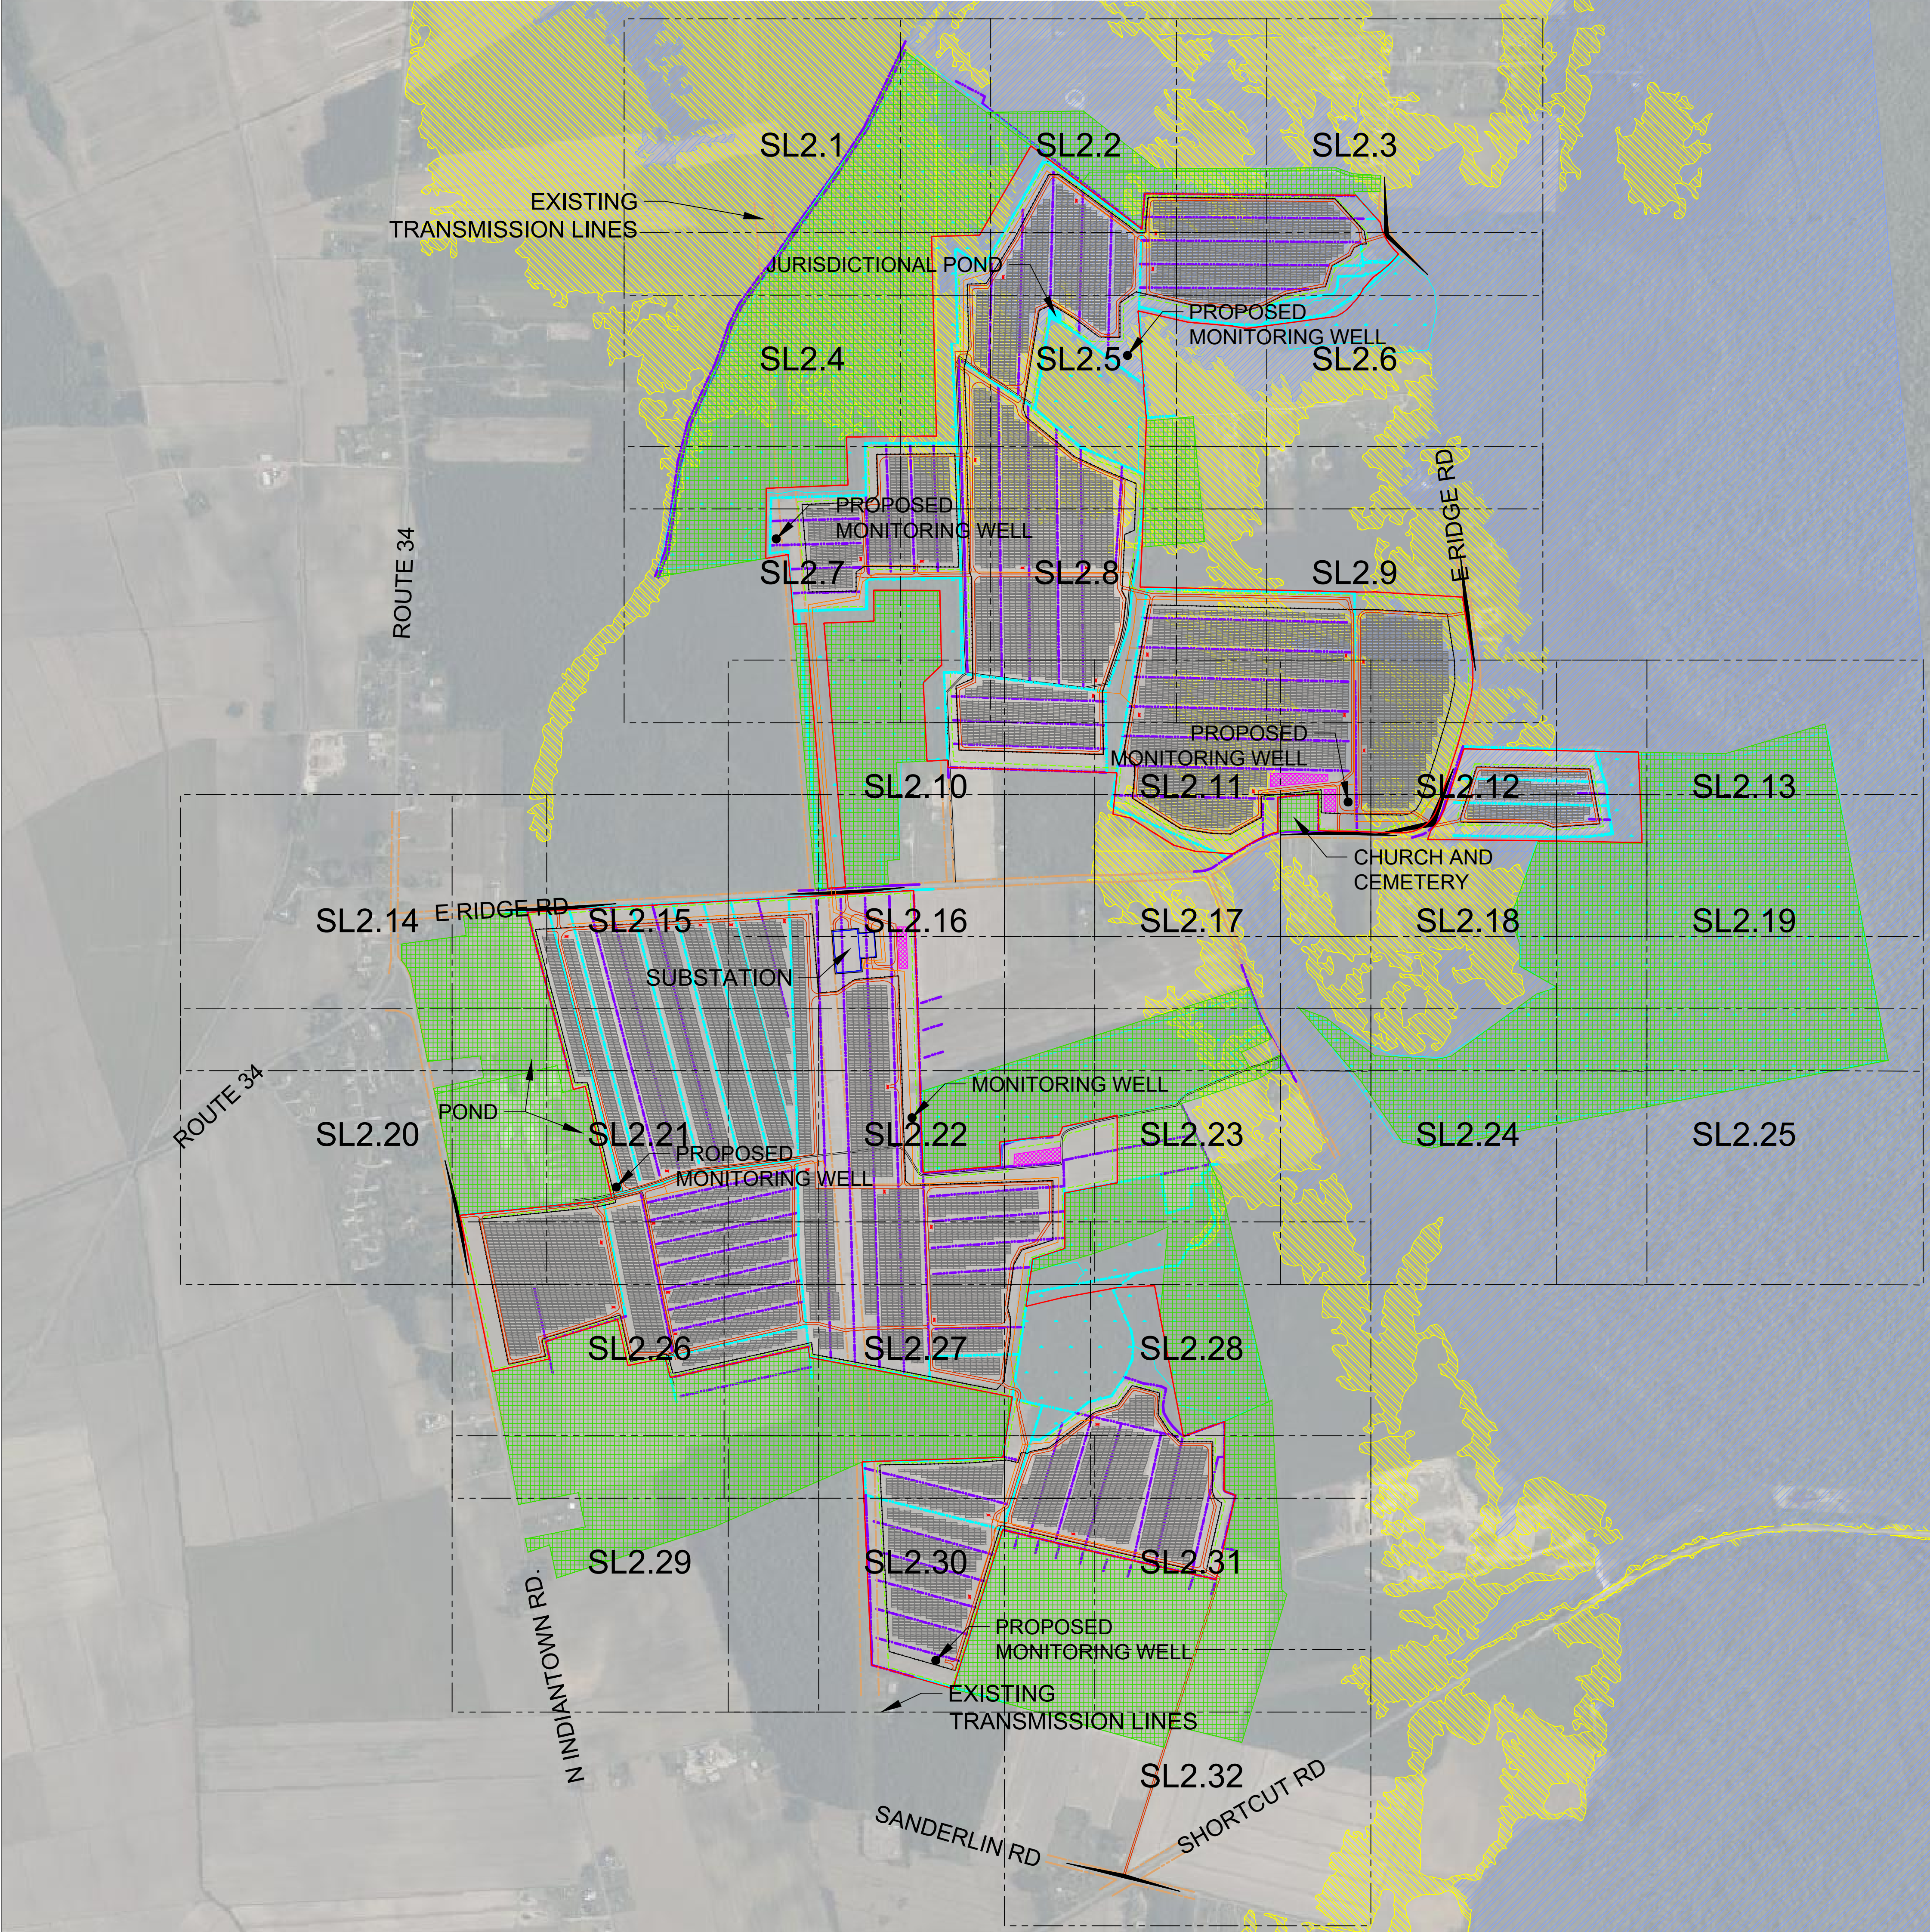

SHAWBORO EAST RIDGE SOLAR, LLC

SITE ADDRESS:
1021 EAST RIDGE RD
SHAWBORO, NC 27973

- NOTES:
- 1. ALL PARCELS USED ARE ZONED AGRICULTURAL
 - 2. ALL EQUIPMENT LOCATIONS ARE PRELIMINARY AND SUBJECT TO CHANGE
 - 3. BUILDINGS THAT HOUSE INVERTER EQUIPMENT MUST FACE AWAY FORM THE NAVAL SUPPORT ACTIVITY NORTHWEST ANNEX
 - 4. A 25 FOOT MAINTENANCE ACCESS DRAINAGE EASEMENT ALONG AT LEAST ONE SIDE OF WATERWAY CONVEYANCE SYSTEMS THAT DRAIN MORE THAN 5 ACRES SHALE BE PROVIDED.
 - 5. VEGETATIVE BUFFER: A TYPE D BUFFER OR AN EXISTING VEGETATIVE BUFFER EQUAL TO A TYPE D BUFFER WILL REMAIN.
 - 6. ALL PROPERTY NOT SHOWN AS BEING IN FLOOD ZONE AE OR THE 0.2% ANNUAL FLOOD HAZARD AREAS IS LOCATED IN FLOOD ZONE X.

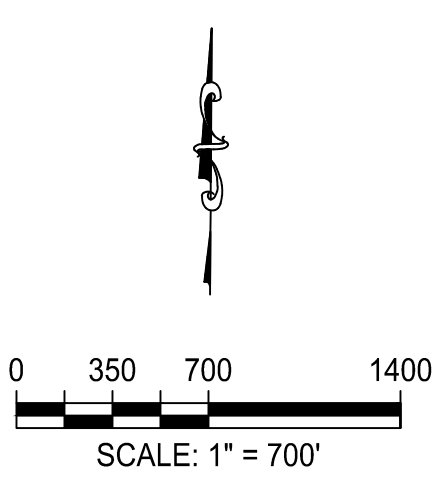



595 Summer St, 4th Floor
Stamford, CT 06901
(203) 983-7875
www.SunEnergy1.com

LEGEND

- PROPERTY LINE

FENCE LINE

PV ARRAY

INVERTER / TRANSFORMER

OVERHEAD COLLECTOR

PROPOSED ACCESS PATHWAY

EXISTING VEHICLE PATH

TYPE D BUFFER*

CONSTRUCTION PARKING, OFFICE, AND DELIVERY AREAS

FLOOD ZONE AE 4FT

0.2% CHANCE OF ANNUAL FLOOD HAZARD

WETLAND

JURISDICTIONAL DITCH

EXISTING DRAINAGE DITCH

EXISTING CULVERTS

RIGHT OF WAYS

Setback Waiver Property
-

DRAWING TITLE		PROJECT OVERVIEW		DRAWING NO.	
SHAWBORO EAST RIDGE SOLAR P/V POWER PLANT IN SHAWBORO, NORTH CAROLINA		AE1-072 DS		SL2.0	
PROJECT NAME	NO.	DATE	DESCRIPTION	PROJECT NAME	NO.
DRAWN	1	03/01/18	PROPERTY CHANGES	12	11/03/24
	2	03/01/18	PROPERTY CHANGES	13A	01/26/24
	3	05/11/15	UPDATE LAYOUT	13	05/17/23
	4	03/02/21	ADDED DETAILS PER COUNTY	14	06/05/24
	5	01/03/21	PROPERTY CHANGES	15	06/12/24
	6	03/17/21	UPDATED LAYOUT	16	07/24/24
	7	03/22/21	REMOVED EASTERN PROPERTY	17	06/10/24
	8	05/03/21	UPDATED LAYOUT AND REMOVED PROPERTY ON INDIANTOWN RD	18	10/07/24
	9	04/22/22	UPDATED LAYOUT	19	11/07/24
	10	08/10/22	EXISTING VEGETATION SUBSTITUTION		
07 NOV 2025	11	08/22/22	UPDATED ZONING SET		
	12	08/22/22	UPDATED ZONING SET		

[illegible]

DRAWING NO.		PROJECT OVERVIEW		DRAWING TITLE	
SL2.1		PROJECT OVERVIEW		SHAWBORO EAST RIDGE SOLAR PV POWER PLANT IN SHAWBORO, NORTH CAROLINA	
PROJECT NAME		AE1-072		DS	
JOB NO.		CHECKED			
LATEST REVISION		DRAWN			
07 NOV 2025		CJM			
NO.		DATE		DESCRIPTION	
1		10/01/16		PROPERTY CHANGES	
2		10/13/16		PROPERTY CHANGES	
3		06/01/16		UPDATE LAYOUT	
4		06/02/16		ADDED DETAILS PER COUNTY	
5		03/05/17		PROPERTY CHANGES	
6		03/17/17		UPDATED LAYOUT	
7		03/22/17		REMOVED EASTERN PROPERTY	
8		05/03/17		REMOVED WESTERN PROPERTY OWN. IN MANTOWN RD.	
9		04/22/17		UPDATED LAYOUT	
10		06/14/16		EXISTING VEGETATION SUBSTITUTION	
11		06/22/16		UPDATED ZONING SET	
12		11/03/22		UPDATED ZONING SET	
13		11/23/22		UPDATED ZONING SET	
14		05/17/23		SHEET S.L.0 PROPERTY INFORMATION	
15		05/17/23		UPDATED ACCESS PATHWAY TO REDUCE	
16		02/09/24		UPDATED LAYOUT	
17		06/19/24		UPDATED SWITCHGEAR AND SUBSTATION	
18		10/19/24		UPDATED LAYOUT	
19		02/01/25		UPDATED ZONING SET	
20		11/01/25		UPDATED ZONING SET	
21		06/19/25		EXISTING VEGETATION SUBSTITUTION	
22		06/22/25		UPDATED ZONING SET	

0

50'


100'

200'


SCALE: 1" = 100'

SUNENERGY1

595 Summer St, 4th Floor
Stamford, CT 06901
(203) 983-7875
www.SunEnergy1.com

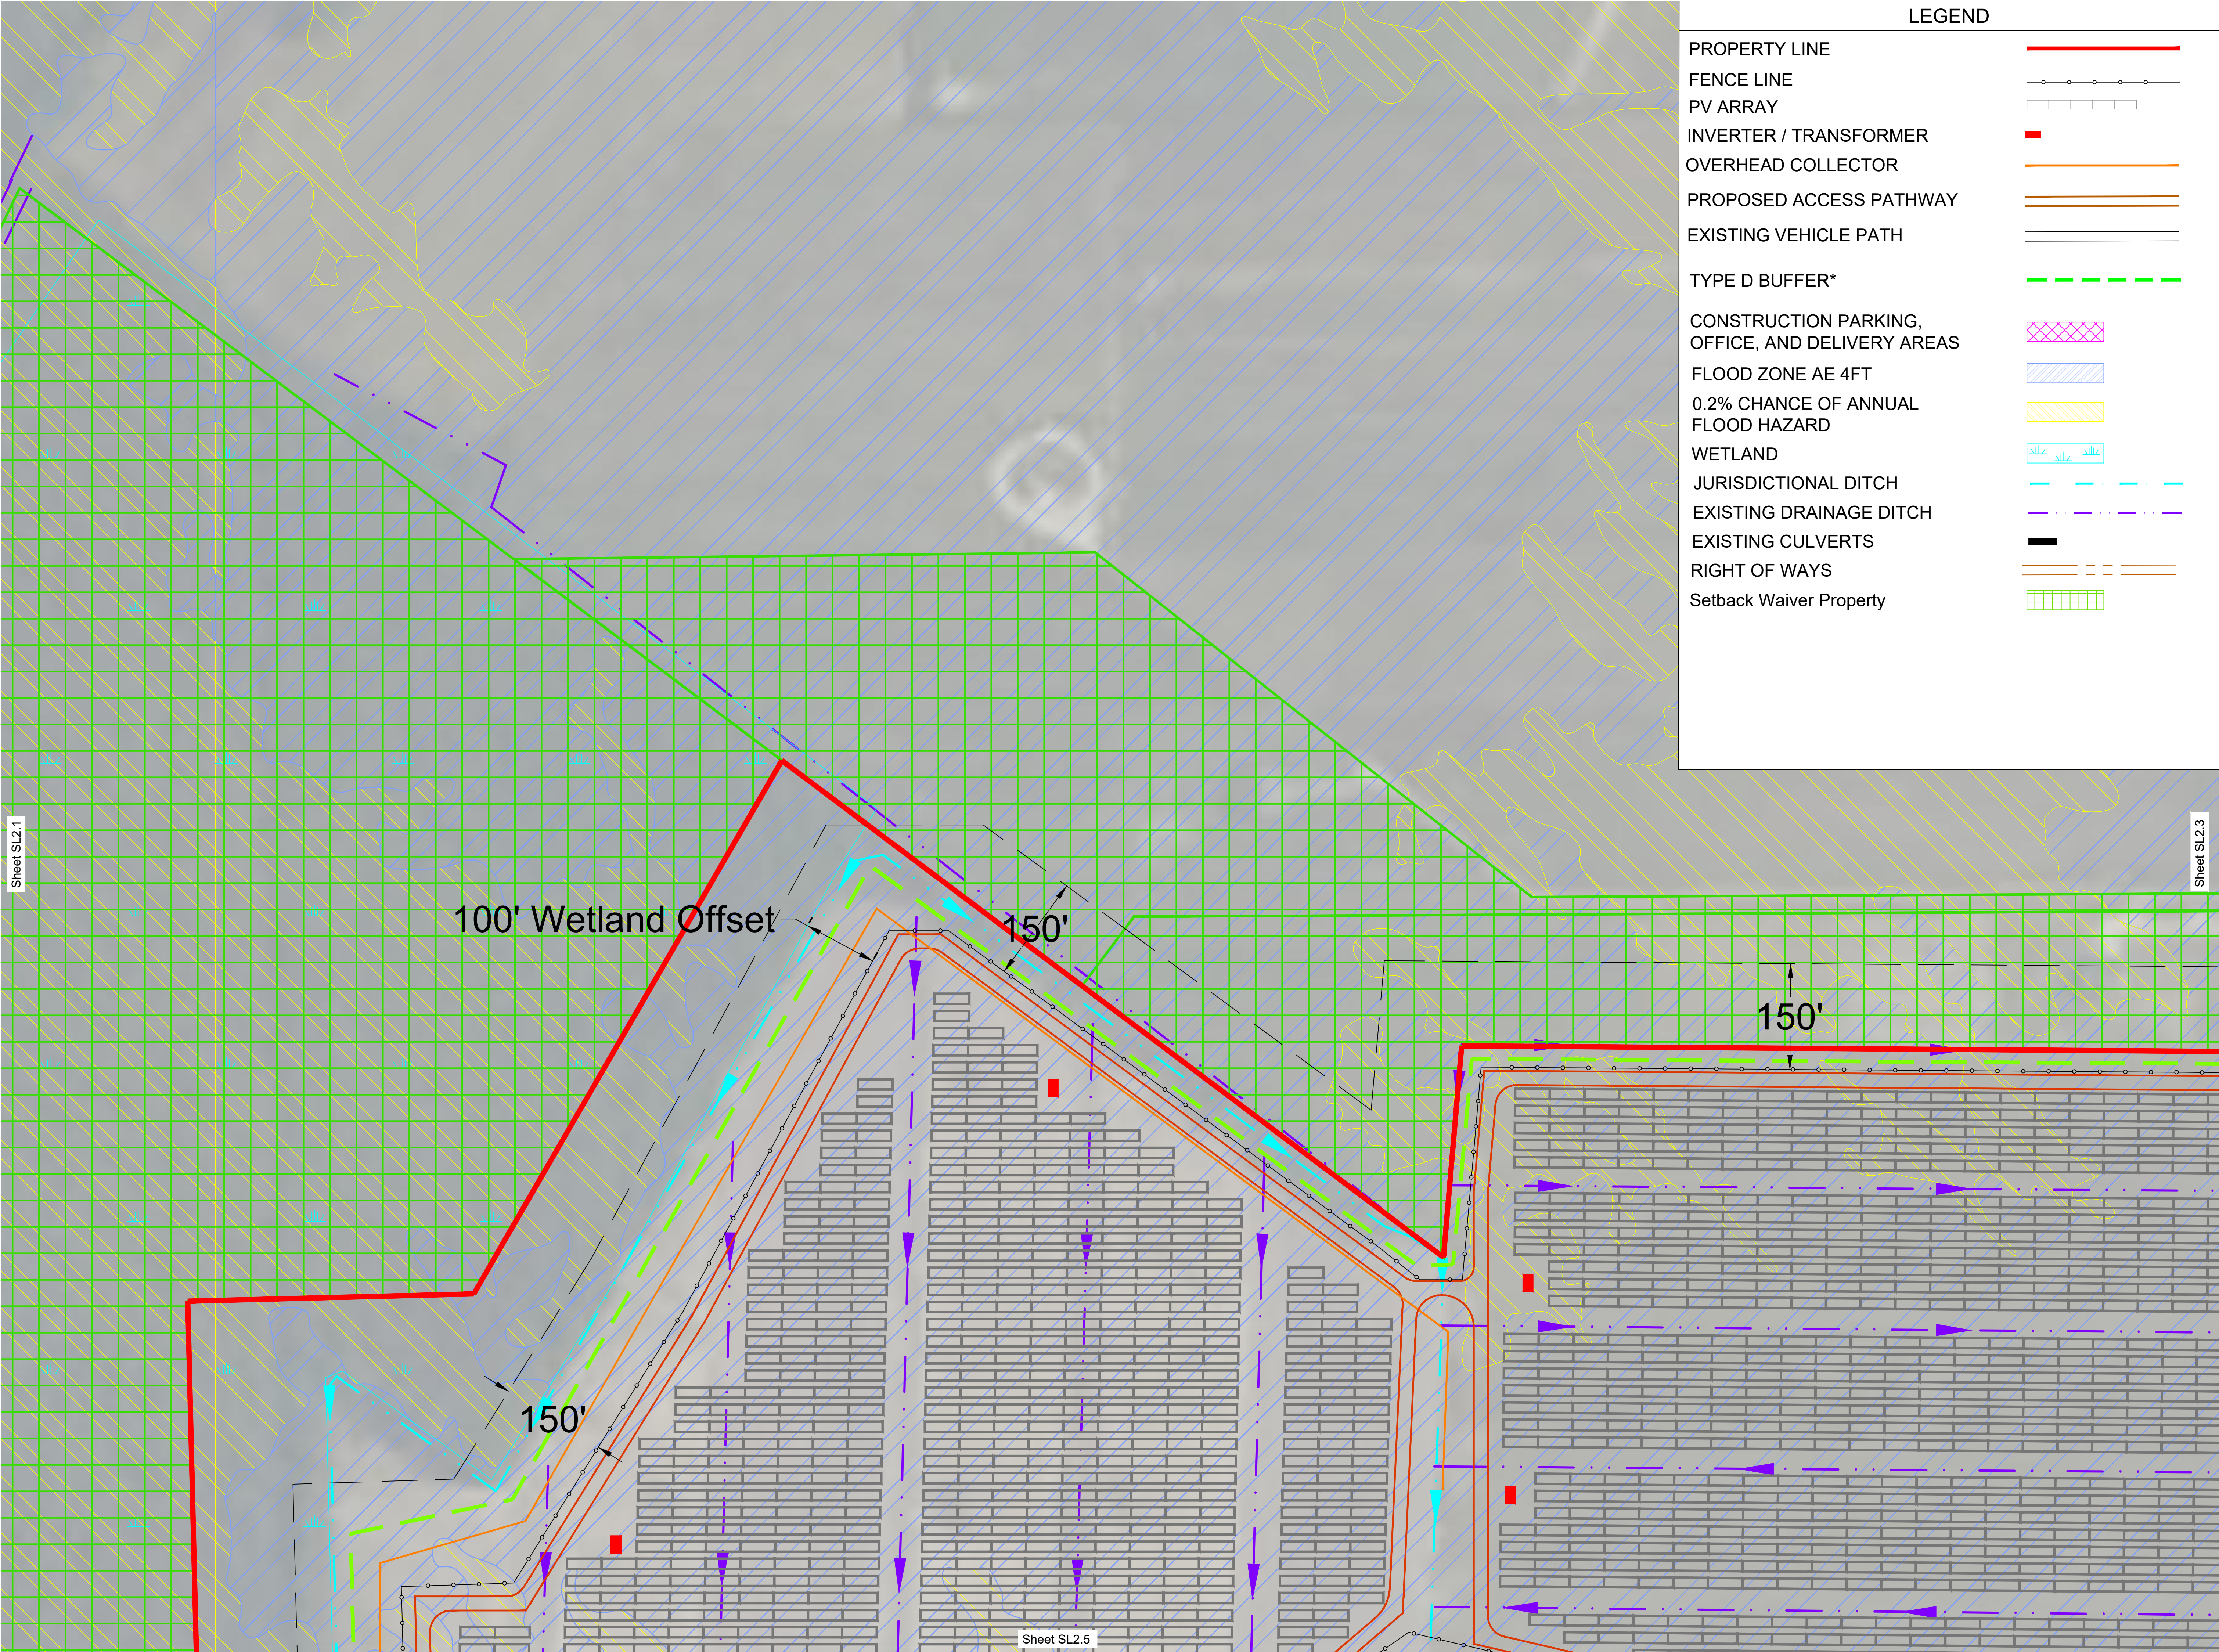


LEGEND	
PROPERTY LINE	
FENCE LINE	
PV ARRAY	
INVERTER / TRANSFORMER	
OVERHEAD COLLECTOR	
PROPOSED ACCESS PATHWAY	
EXISTING VEHICLE PATH	
TYPE D BUFFER*	
CONSTRUCTION PARKING, OFFICE, AND DELIVERY AREAS	
FLOOD ZONE AE 4FT	
0.2% CHANCE OF ANNUAL FLOOD HAZARD	
WETLAND	
JURISDICTIONAL DITCH	
EXISTING DRAINAGE DITCH	
EXISTING CULVERTS	
RIGHT OF WAYS	
Setback Waiver Property	

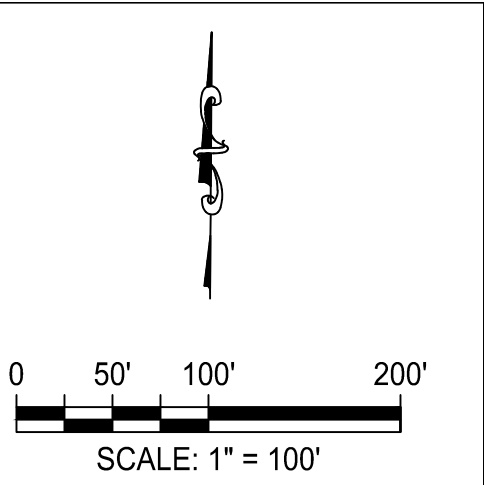






595 Summer St, 4th Floor
Stamford, CT 06901
(203) 983-7875
www.SunEnergy1.com

PROJECT NAME SHAWBORO EAST RIDGE SOLAR PV POWER PLANT IN SHAWBORO, NORTH CAROLINA JOB NO. AE1-072 LATEST REVISION 07 NOV 2025	DRAWING TITLE PROJECT OVERVIEW DRAWING NO. SL2.2	NO.	DATE	DESCRIPTION	NO.	DATE	DESCRIPTION
		1	06/08/18	PROPERTY CHANGES	12	11/08/24	UPDATED ZONING SET
		2	01/31/18	PROPERTY CHANGES	13	01/26/24	UPDATED ZONING SET
		3	06/31/18	UPDATE LAYOUT	14	05/17/23	UPDATED ACCESS PATHWAY TO REDUCE
		4	06/30/21	ADDED DETAILS PER COUNTY	15	05/05/24	UPDATED LAYOUT
		5	06/05/21	PROPERTY CHANGES	16	06/19/24	UPDATED SWITCHYARD AND SUBSTATION
		6	03/11/21	UPDATED LAYOUT	17	02/10/24	UPDATED LAYOUT
		7	09/22/21	REMOVED EASTERN PROPERTY	18	02/10/24	UPDATED LAYOUT
		8	06/04/21	UPDATED LAYOUT AND REMOVED PROPERTY ON INDIANTOWN RD	19	10/07/24	UPDATED ZONING SET
		9	04/22/22	EXISTING VEGETATION SUBSTITUTION			
		10	06/14/22	EXISTING VEGETATION SUBSTITUTION			
		11	06/22/22	UPDATED ZONING SET			

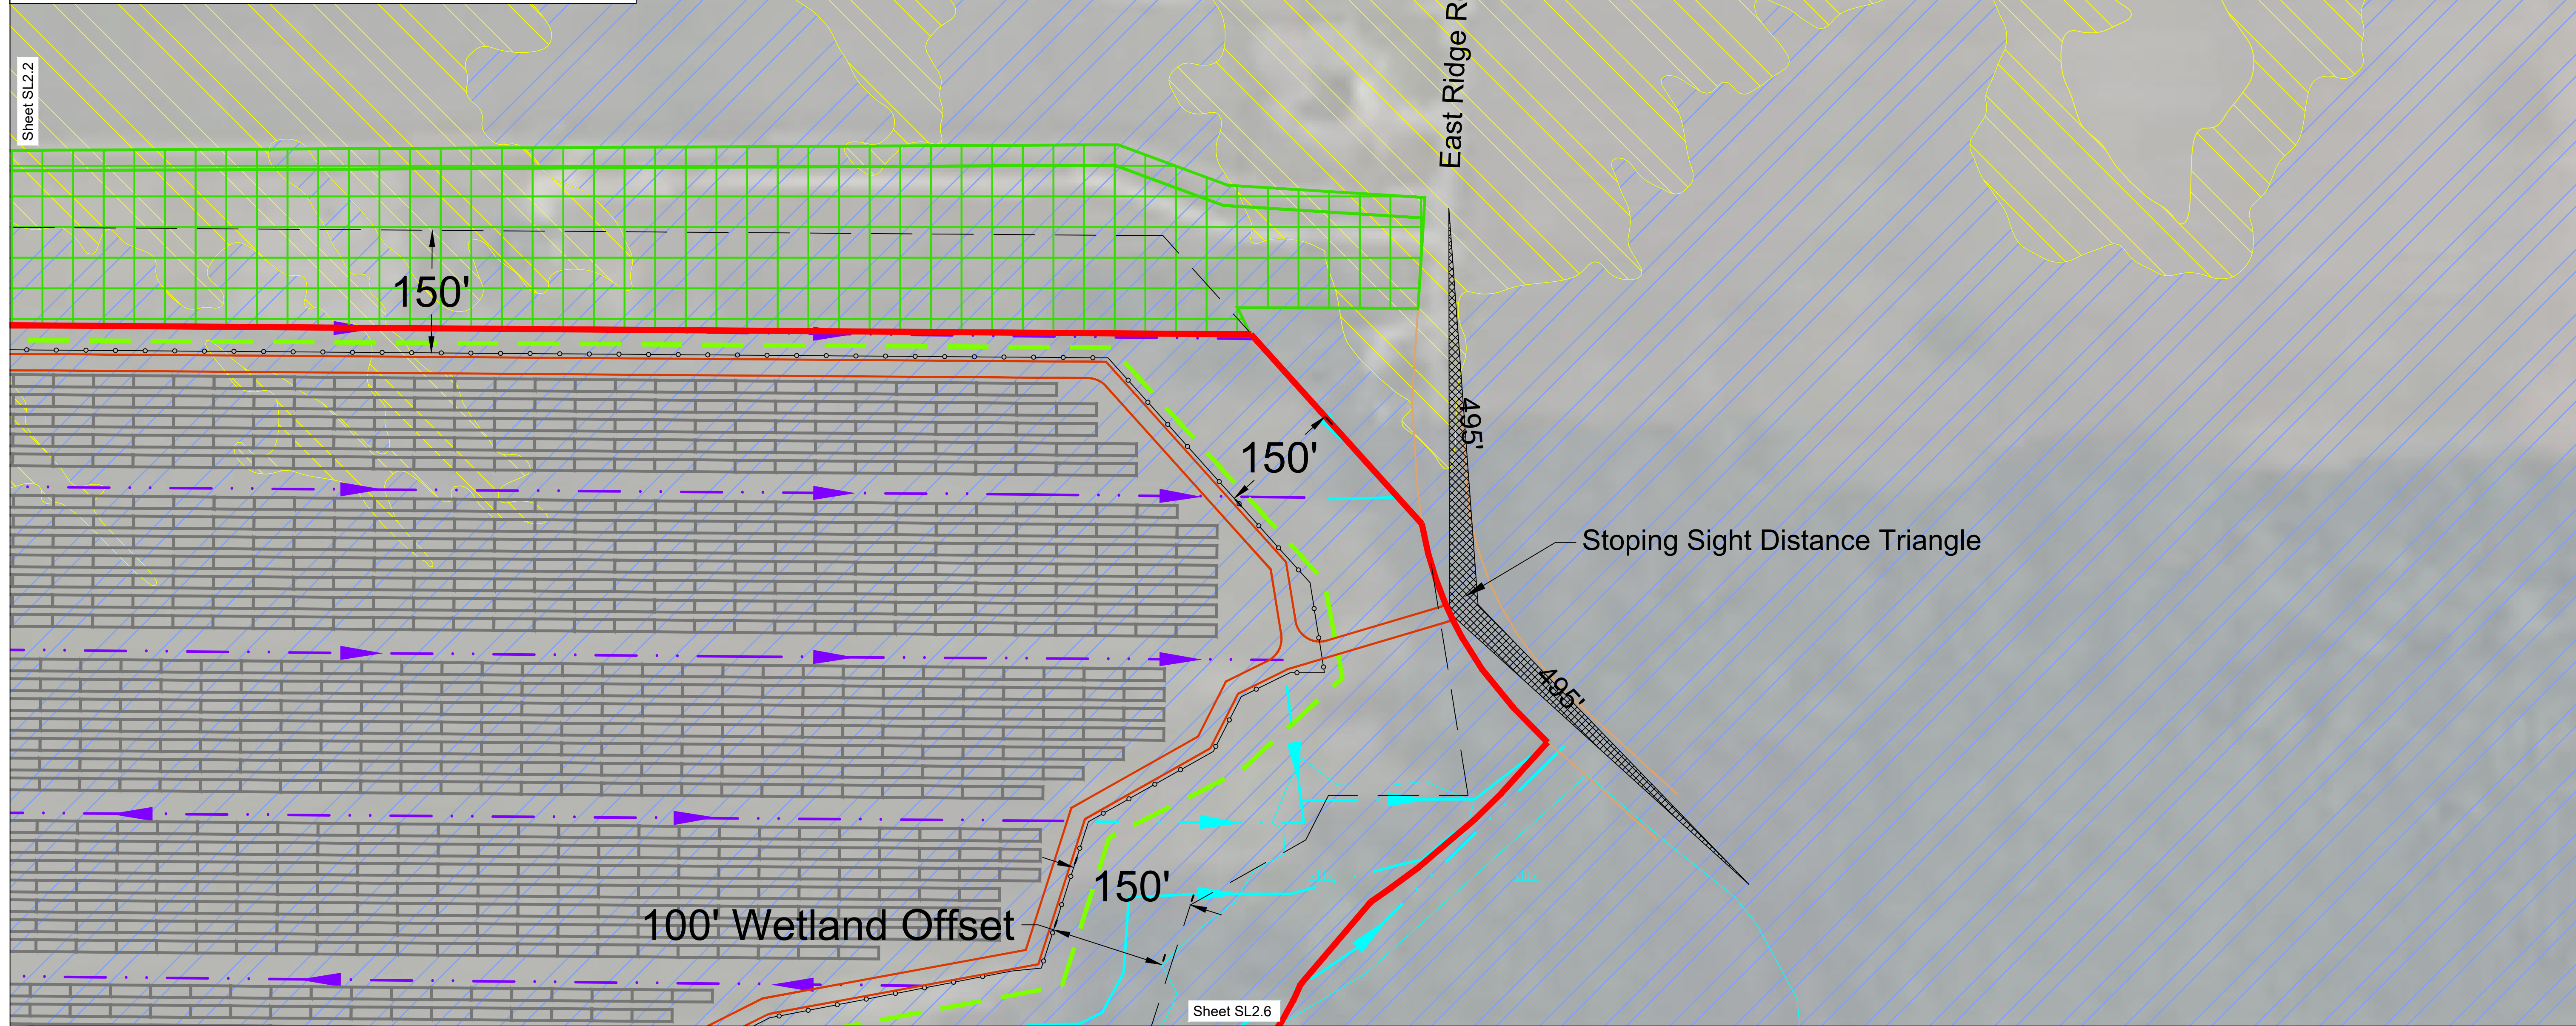[illegible]

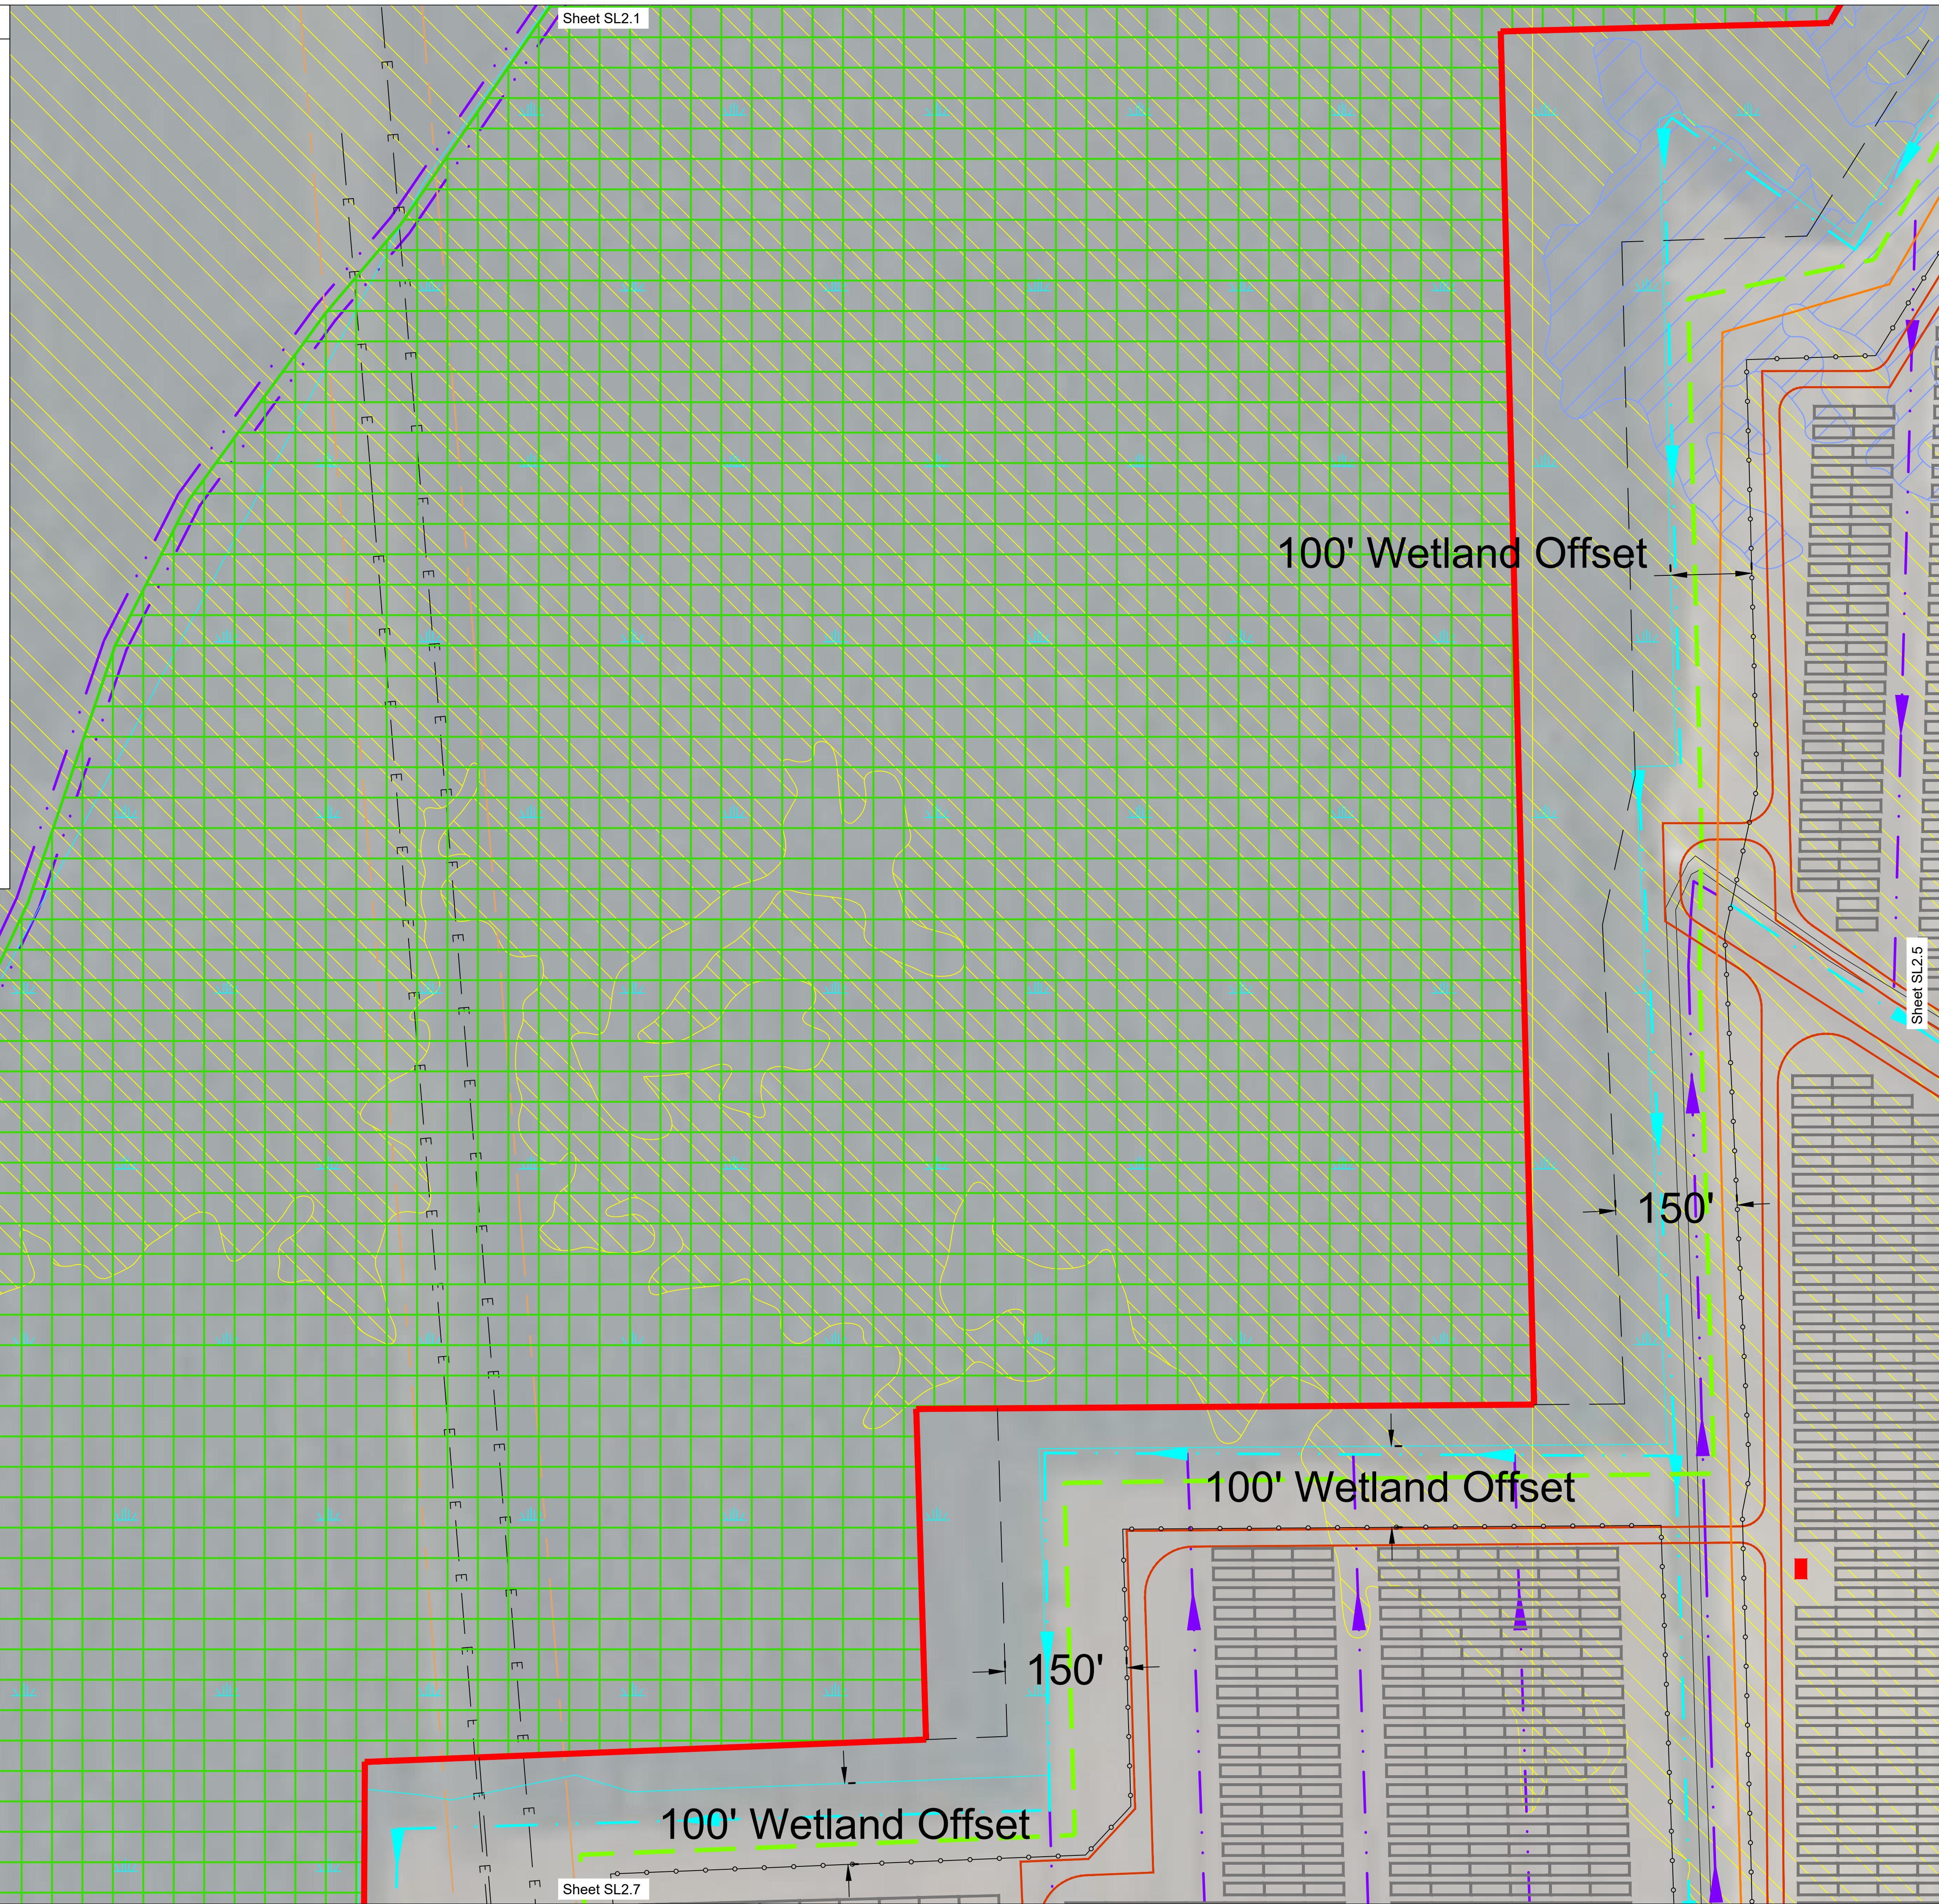

DRAWING NO.		PROJECT OVERVIEW		DRAWING TITLE	
SL2.4		PROJECT OVERVIEW		SHAWBORO EAST RIDGE SOLAR PV POWER PLANT IN SHAWBORO, NORTH CAROLINA	
PROJECT NAME		JOB NO.		CHECKED	
AE1-072		DS		11/03/22	
LATEST REVISION		DRAWN		11/03/22	
07 NOV 2025		CJM		11/03/22	
NO		DATE		DESCRIPTION	
1		11/03/22		UPDATED ZONING SET	
2		11/03/22		PROPERTY CHANGES	
3		11/03/22		PROPERTY CHANGES	
4		11/03/22		PROPERTY CHANGES	
5		11/03/22		PROPERTY CHANGES	
6		11/03/22		PROPERTY CHANGES	
7		11/03/22		PROPERTY CHANGES	
8		11/03/22		PROPERTY CHANGES	
9		11/03/22		PROPERTY CHANGES	
10		11/03/22		PROPERTY CHANGES	
11		11/03/22		PROPERTY CHANGES	

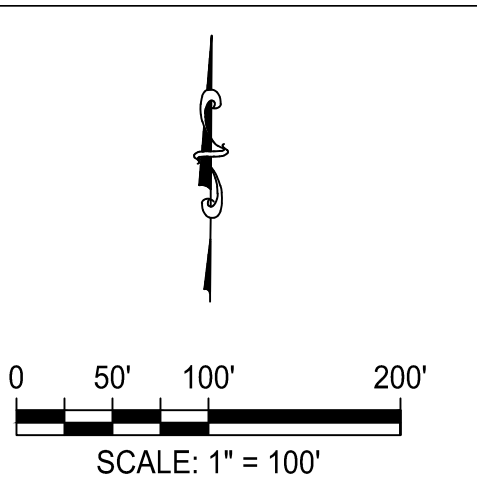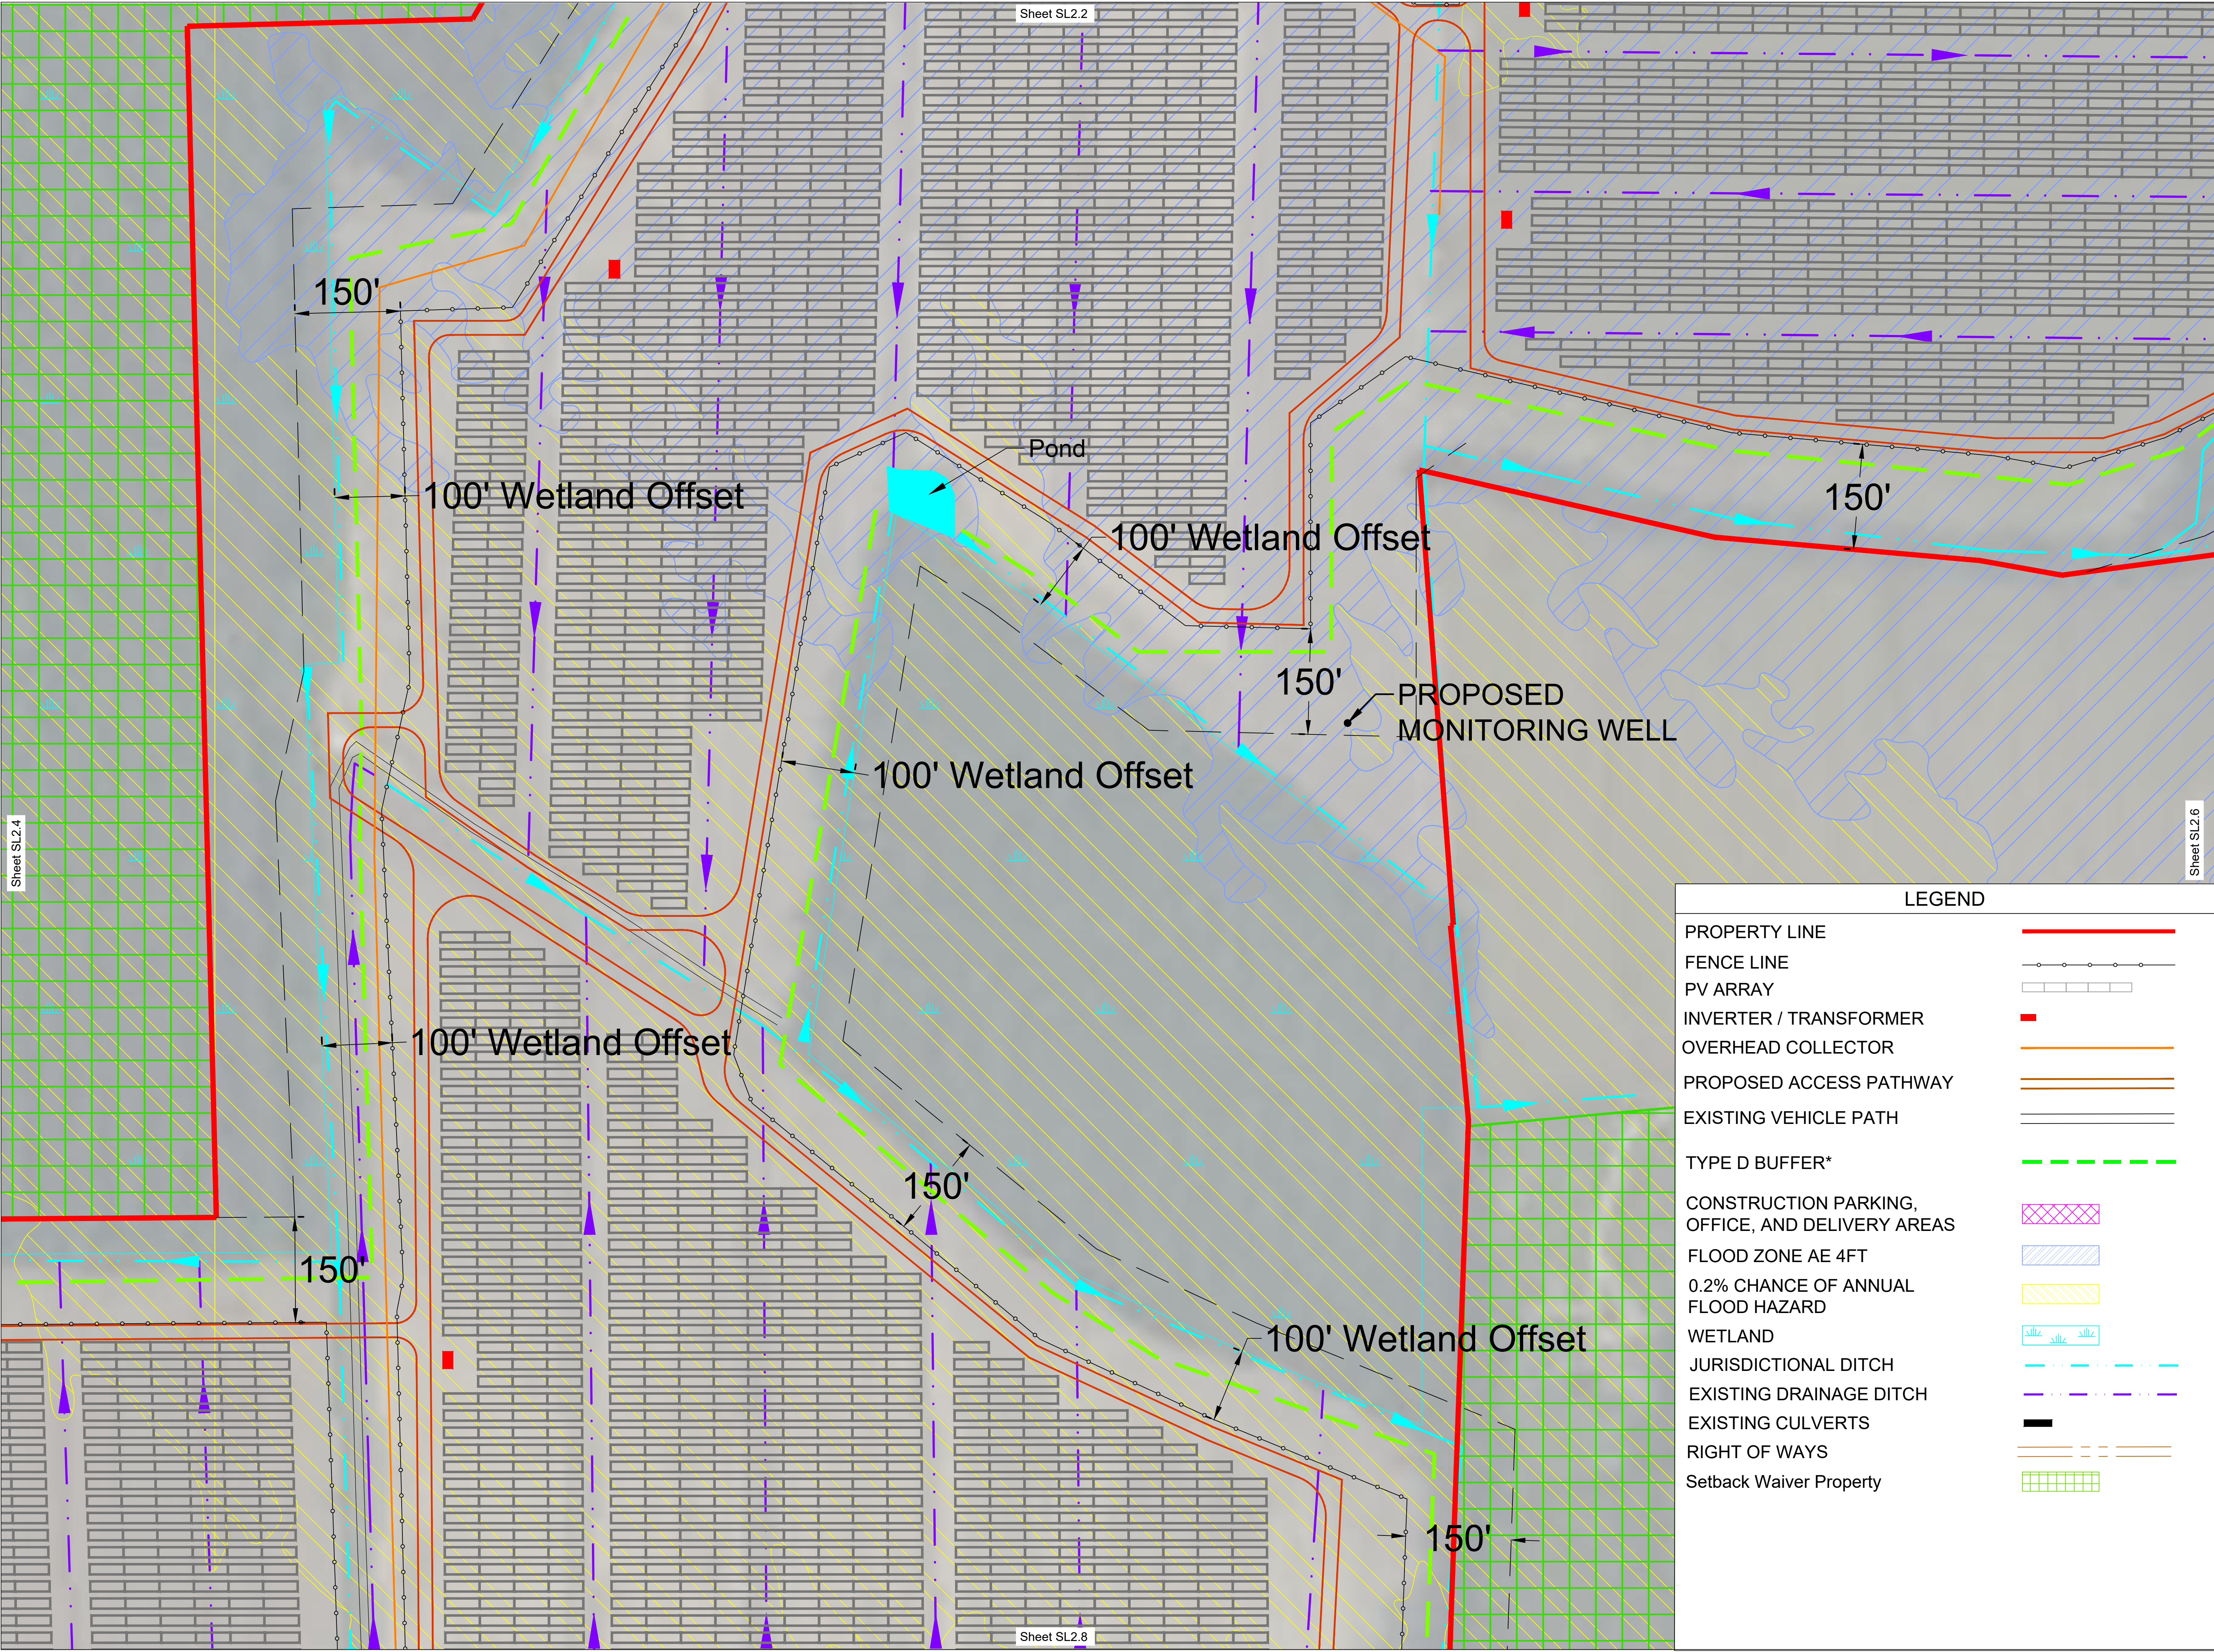



SUNENERGY1
595 Summer St, 4th Floor
Stamford, CT 06901
(203) 983-7875
www.SunEnergy1.com

LEGEND	
PROPERTY LINE	
FENCE LINE	
PV ARRAY	
INVERTER / TRANSFORMER	
OVERHEAD COLLECTOR	
PROPOSED ACCESS PATHWAY	
EXISTING VEHICLE PATH	
TYPE D BUFFER*	
CONSTRUCTION PARKING, OFFICE, AND DELIVERY AREAS	
FLOOD ZONE AE 4FT	
0.2% CHANCE OF ANNUAL FLOOD HAZARD	
WETLAND	
JURISDICTIONAL DITCH	
EXISTING DRAINAGE DITCH	
EXISTING CULVERTS	
RIGHT OF WAYS	
Setback Waiver Property	

DRAWING TITLE									
PROJECT OVERVIEW									
DRAWING NO. SL2.5									
PROJECT NAME									
SHAWBORO EAST RIDGE SOLAR PV POWER PLANT IN SHAWBORO, NORTH CAROLINA									
JOB NO.									
CHECKED									
AE1-072									
DS									
DRAWN									
LATEST REVISION									
07 NOV 2025									
CJM									
NO. DATE DESCRIPTION									
1 11/03/24 UPDATED ZONING SET									
2 12A 01/23/25 UPDATED ZONING SET									
3 01/31/16 PROPERTY CHANGES SHEET 54.0 PROPERTY INFORMATION									
4 05/11/16 PROPERTY CHANGES SHEET 54.0 ACCESS PATHWAY TO REDUCE IMPACTS									
5 05/25/24 UPDATED LAYOUT									
6 06/19/24 UPDATED SWITCHYARD AND SUBSTATION									
7 03/03/25 PROPERTY CHANGES									
8 03/17/21 UPDATED LAYOUT									
9 02/10/25 UPDATED LAYOUT									
10 10/07/25 UPDATED ZONING SET									
11 05/05/24 EXISTING VEGETATION AND PROPERTY CAN REMOVED									
12 04/22/25 UPDATED LAYOUT									
13 06/10/25 EXISTING VEGETATION SUBSTITUTION NOTE									
14 05/22/25 UPDATED ZONING SET									

[illegible]

DRAWING NO.		SL2.9	
DRAWING TITLE		PROJECT OVERVIEW	
PROJECT NAME		SHAWBORO EAST RIDGE SOLAR PV / POWER PLANT IN SHAWBORO, NORTH CAROLINA	
JOB NO.		CHECKED	
DATE		AE1-072	DS
LATEST REVISION		DRAWN	
07 NOV 2025		CJM	
NO.		DATE	DESCRIPTION
1	3/20/16	PROPERTY CHANGES	12/11/2025 UPDATED ZONING SET
2	3/20/16	PROPERTY CHANGES	12/11/2025 UPDATED ZONING SET
3	3/21/16	UPDATE LAYOUT	12/11/2025 UPDATED ACCESS PATHWAY TO REDUCE
4	3/21/16	ADDED DETAILS PER COUNTY	12/11/2025 UPDATED LAYOUT
5	3/21/16	PROPERTY CHANGES	12/11/2025 UPDATED SWITCHING AND SUBSTITUTION
6	3/21/16	UPDATE LAYOUT	12/11/2025 UPDATED LAYOUT
7	3/22/16	REMOVED EASTERN PROPERTY	12/11/2025 UPDATED ZONING SET
8	3/22/16	UPDATED LAYOUT AND REMOVED	12/11/2025 UPDATED ZONING SET
9	3/22/16	UPDATE LAYOUT	12/11/2025 UPDATED ZONING SET
10	3/22/16	EXISTING VEGETATION SUBSTITUTION	12/11/2025
11	3/22/16	UPDATE ZONING SET	12/11/2025

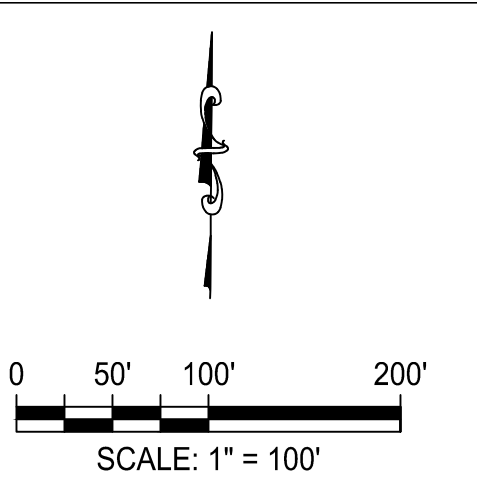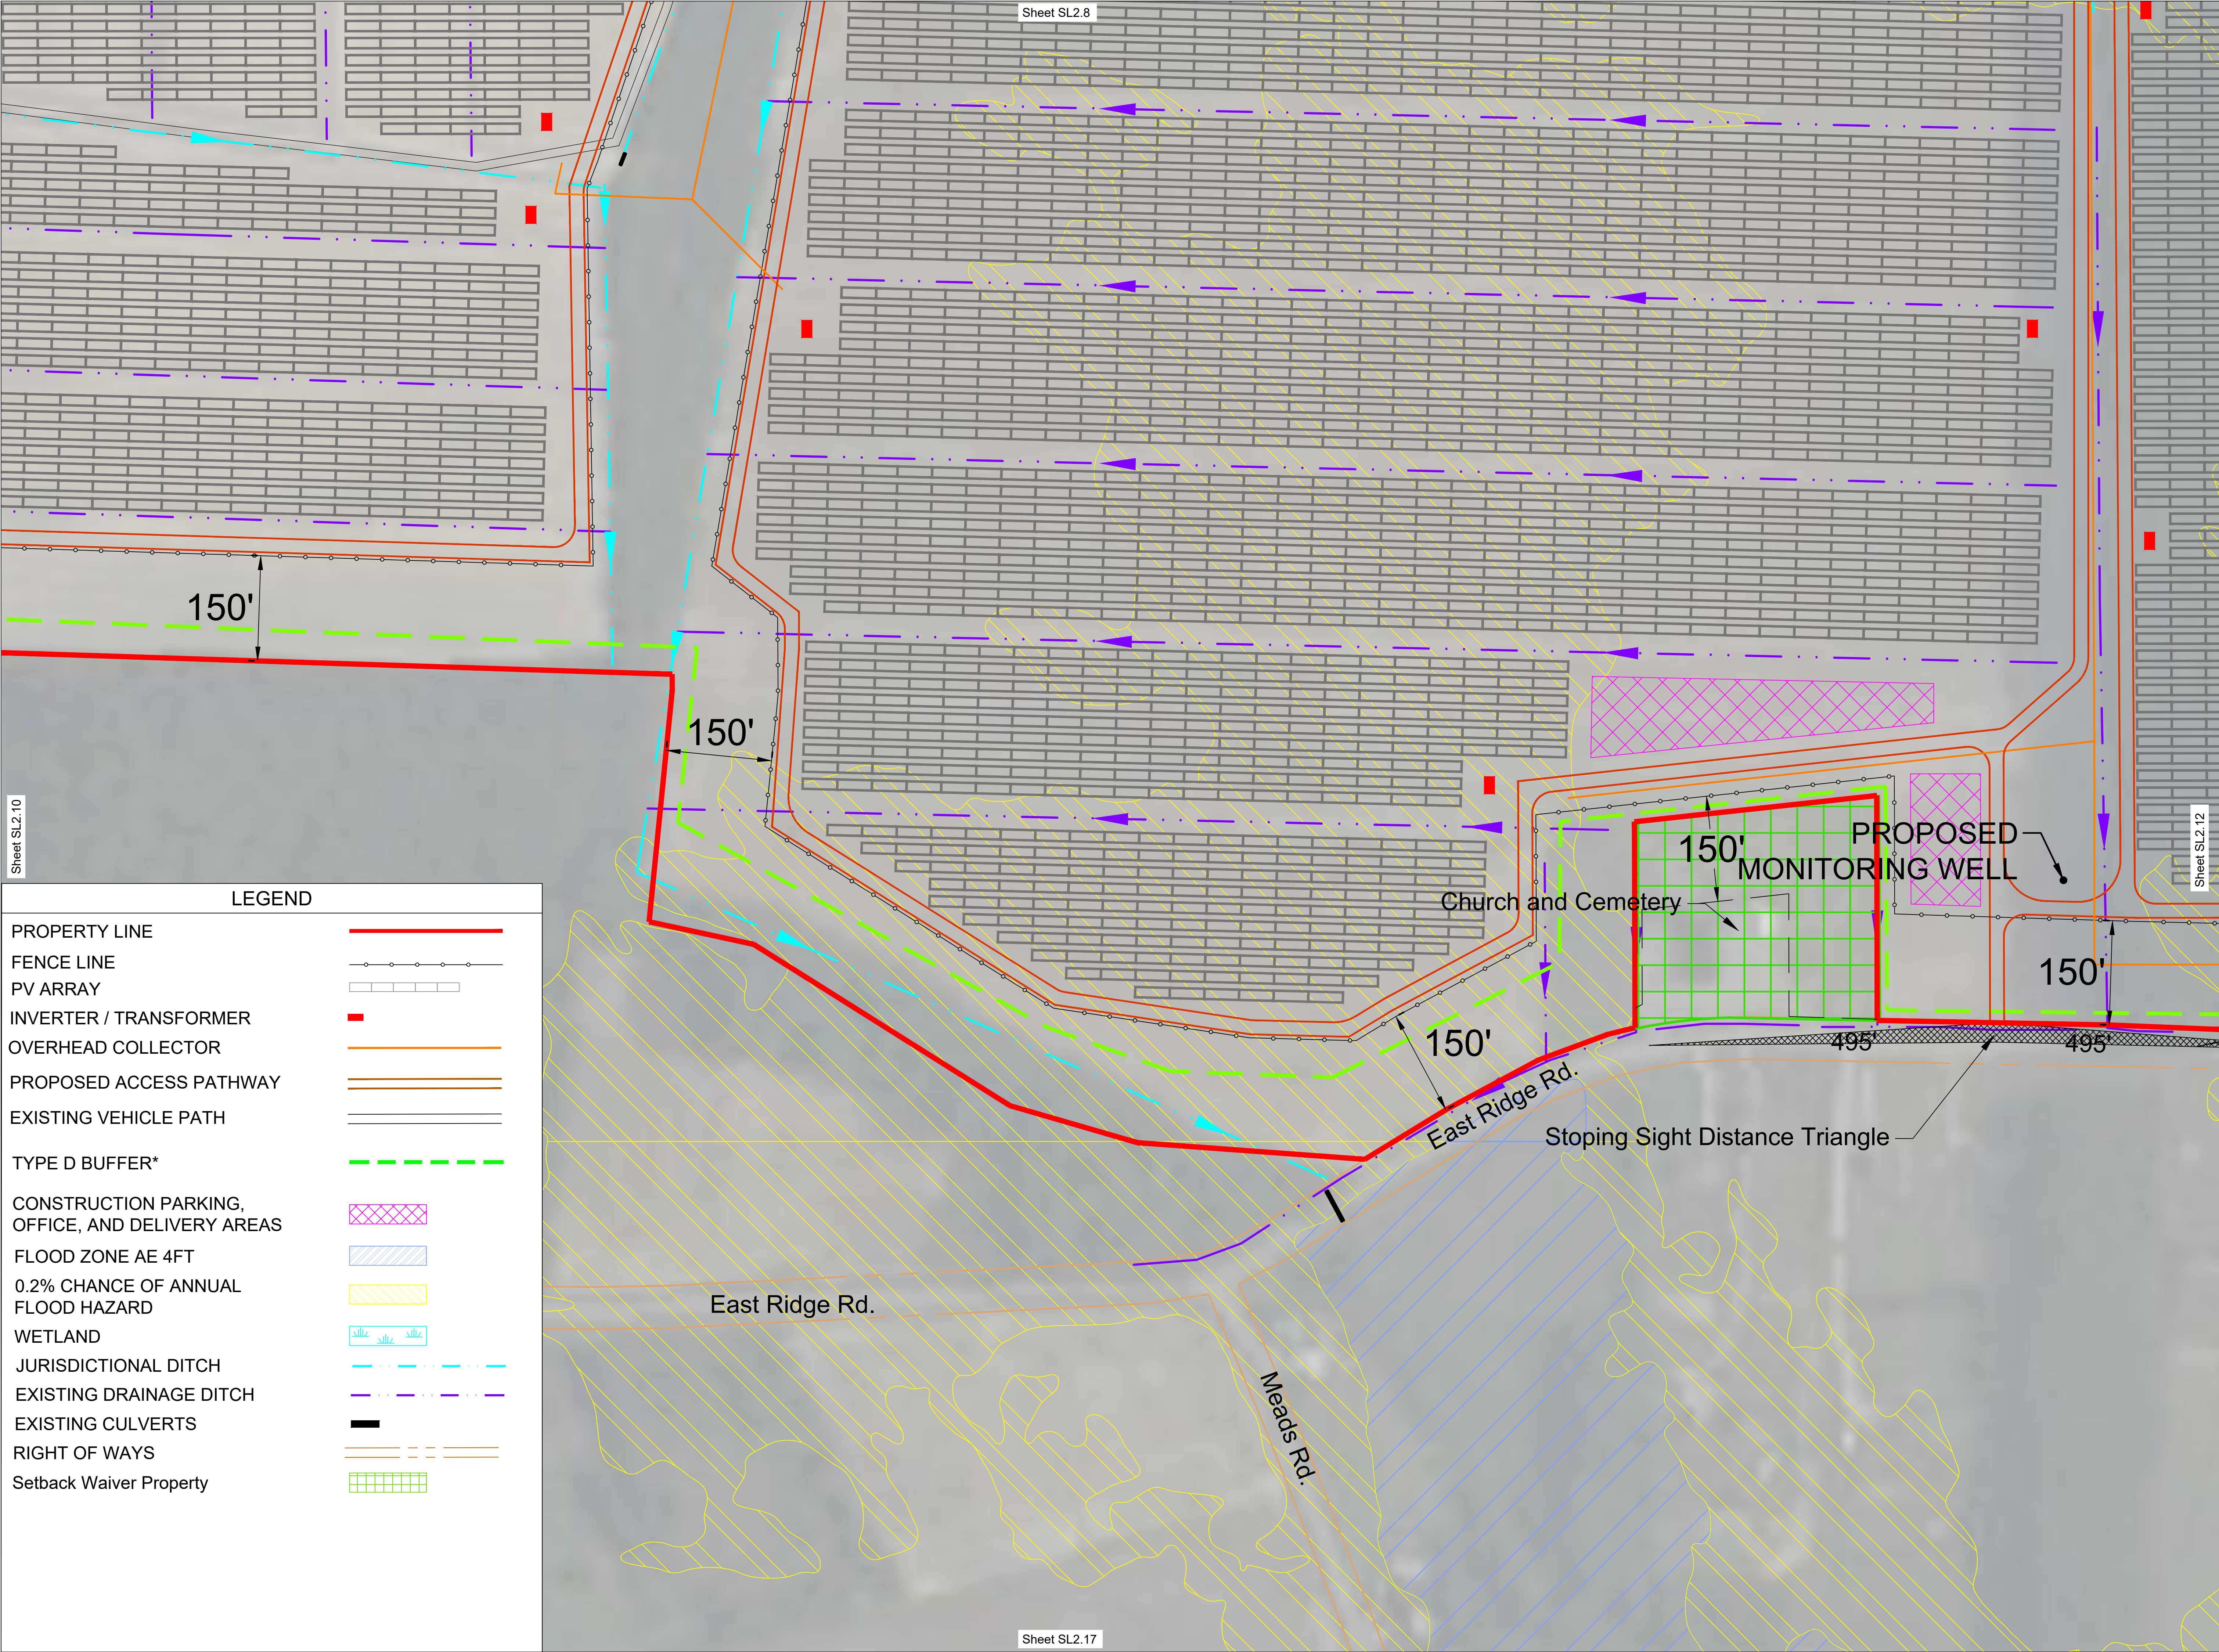


SUNENERGY1
595 Summer St, 4th Floor
Stamford, CT 06901
(203) 983-7875
www.SunEnergy1.com


LEGEND	
PROPERTY LINE	
FENCE LINE	
PV ARRAY	
INVERTER / TRANSFORMER	
OVERHEAD COLLECTOR	
PROPOSED ACCESS PATHWAY	
EXISTING VEHICLE PATH	
TYPE D BUFFER*	
CONSTRUCTION PARKING, OFFICE, AND DELIVERY AREAS	
FLOOD ZONE AE 4FT	
0.2% CHANCE OF ANNUAL FLOOD HAZARD	
WETLAND	
JURISDICTIONAL DITCH	
EXISTING DRAINAGE DITCH	
EXISTING CULVERTS	
RIGHT OF WAYS	
Setback Waiver Property	

NO.	DATE	DESCRIPTION
1	06/08/18	PROPERTY CHANGES
2	01/13/19	PROPERTY CHANGES
3	06/01/19	UPDATE LAYOUT
4	08/02/21	ADDED DETAILS PER COUNTY
5	08/05/21	PROPERTY CHANGES
6	03/17/21	UPDATE LAYOUT
7	09/22/21	REMOVED EASTERN PROPERTY
8	06/02/21	UPDATE LAYOUT AND REMOVED PROPERTY ON MOUNTAIN RD.
9	04/22/22	UPDATE LAYOUT
10	06/14/22	EXISTING VEGETATION SUBSTITUTION
11	09/22/22	UPDATE ZONING SET
12	11/03/21	UPDATE ZONING SET
13	01/28/23	UPDATE ZONING SET
14	02/05/24	UPDATE ACCESS PATHWAY TO REDUCE
15	06/12/24	UPDATE SWITCHYARD AND SUBSTATION
16	01/24/25	UPDATE LAYOUT
17	02/10/25	UPDATE LAYOUT
18	01/07/25	UPDATE ZONING SET
19	01/07/25	UPDATE ZONING SET
20	01/07/25	UPDATE ZONING SET


PROJECT NAME	SHAWBORO EAST RIDGE SOLAR
DRAWING TITLE	PROJECT OVERVIEW
PROJECT NO.	AE1-072
DESIGNER	DS
DRAWN	CJM
DATE	07 NOV 2025
REVISION	

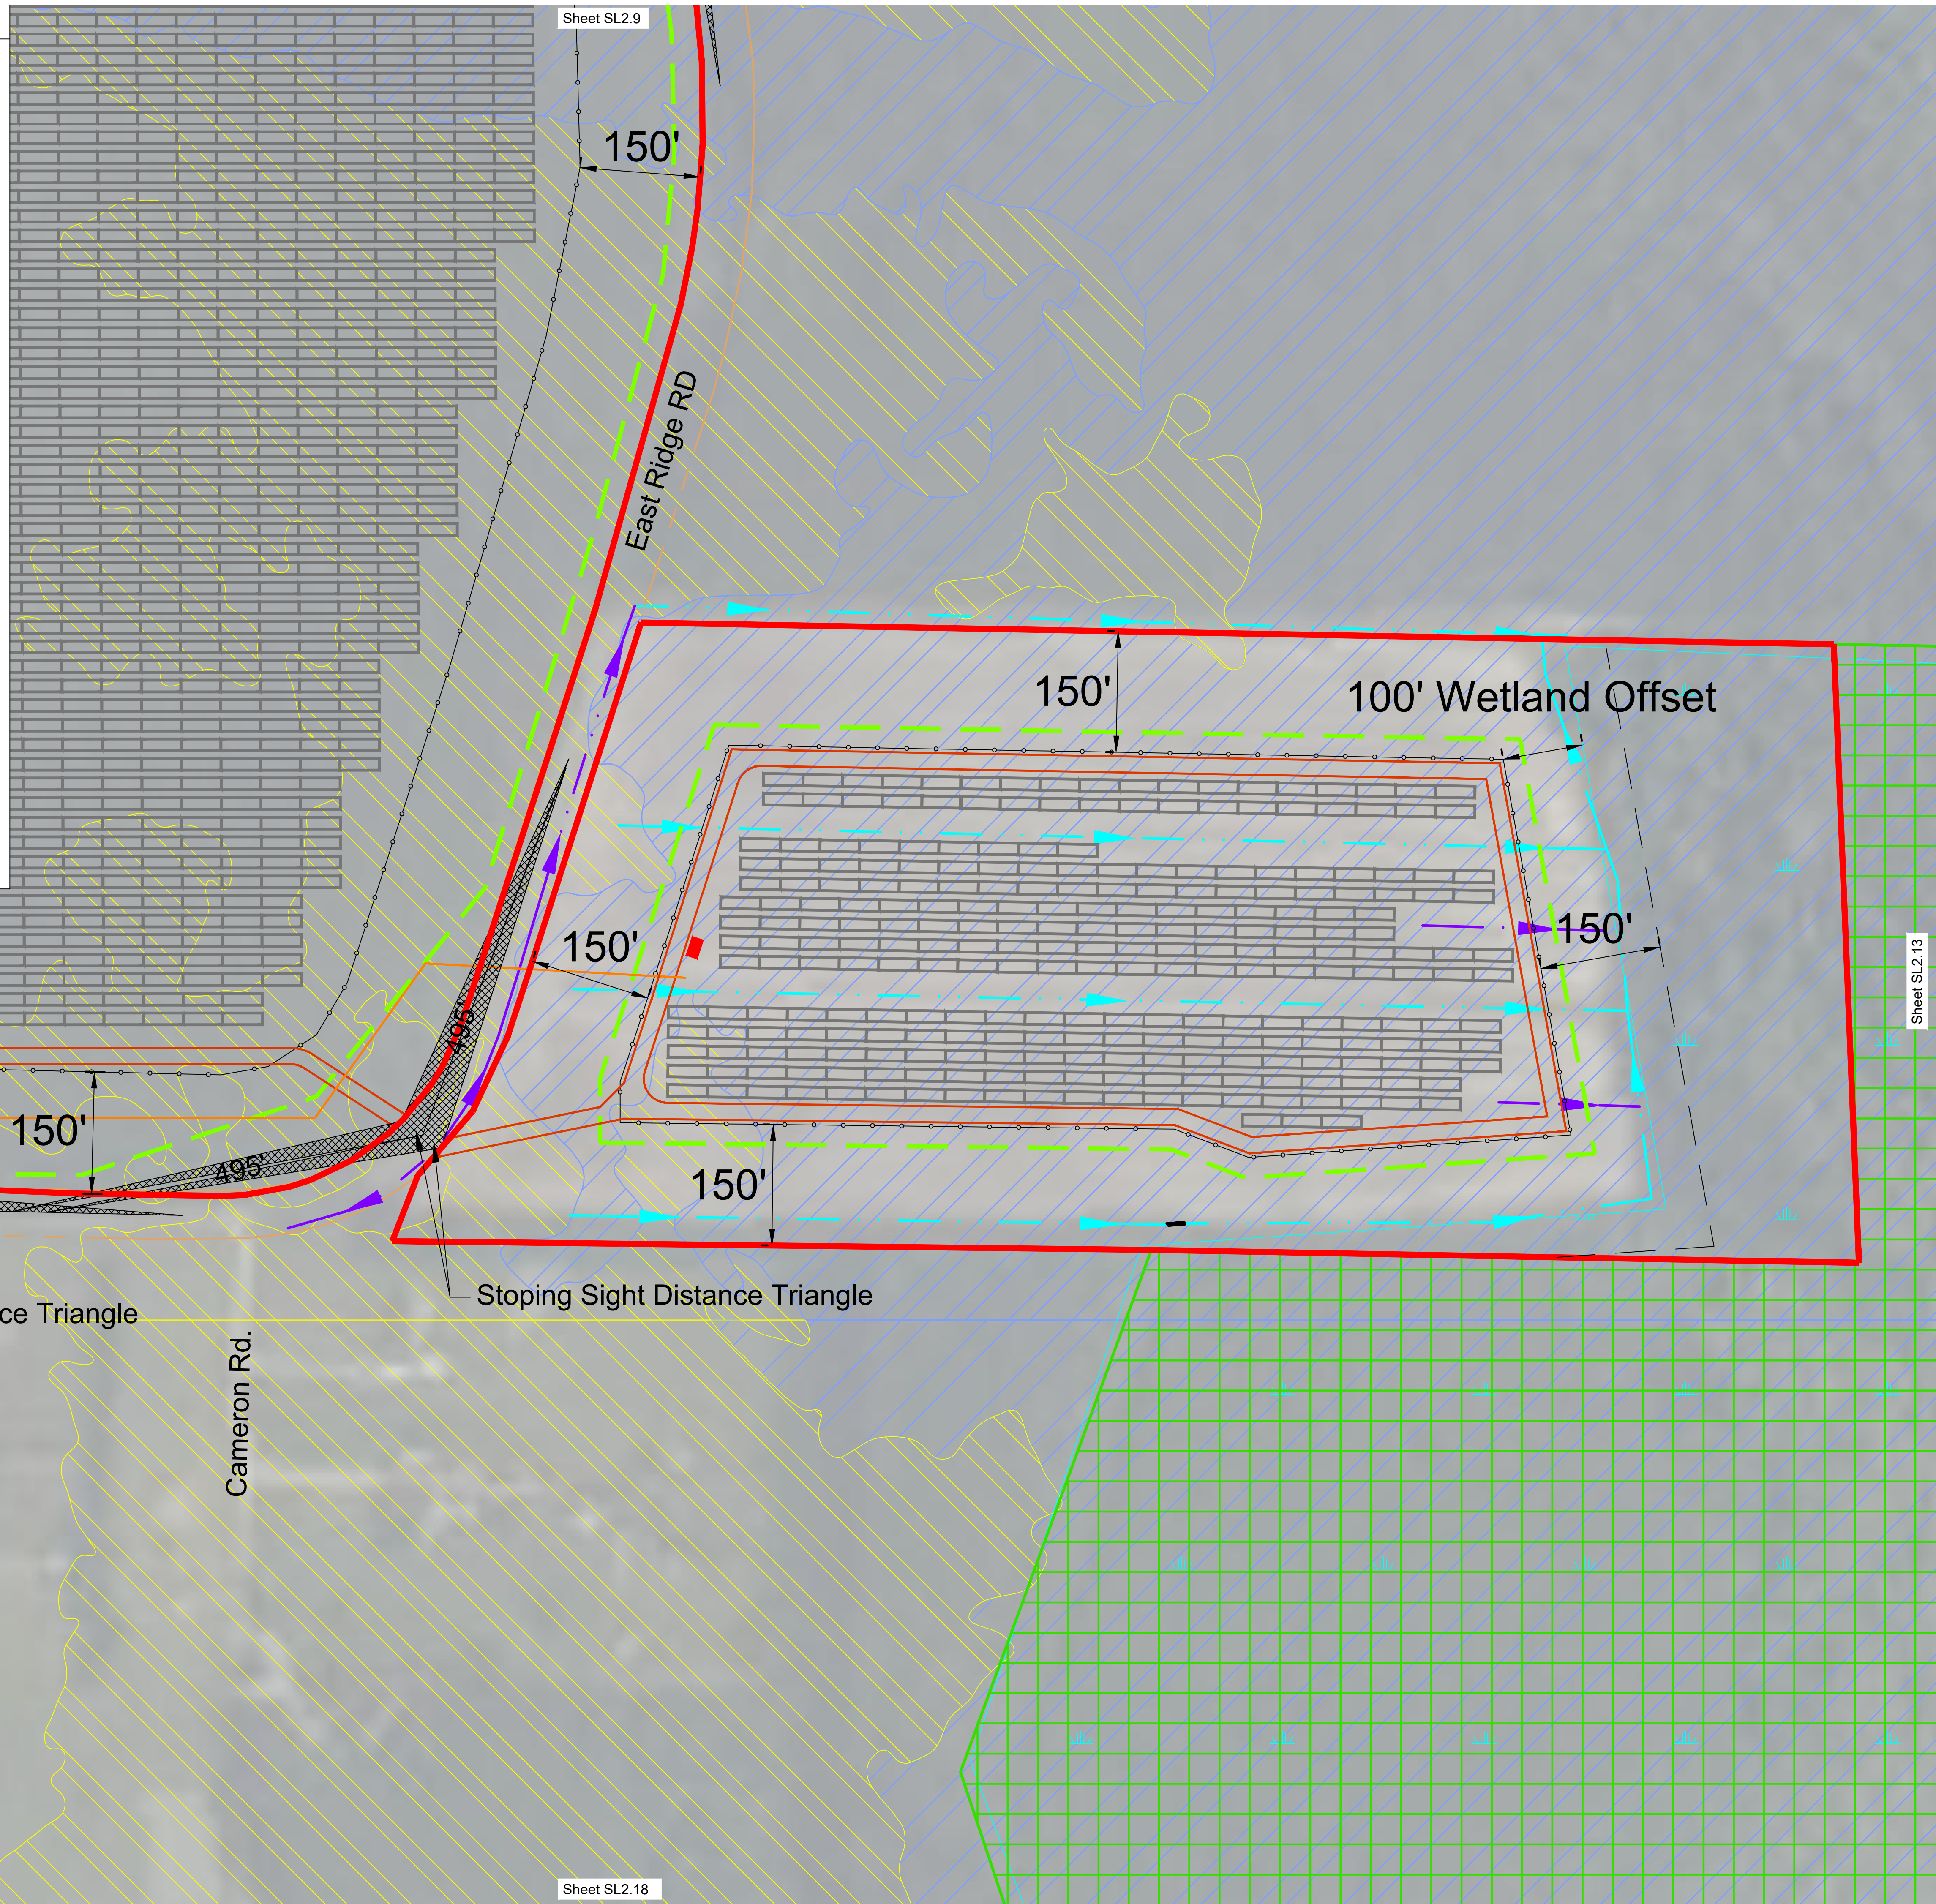

DRAWING NO.		PROJECT OVERVIEW		DRAWING TITLE	
SL2.12		SHAWBORO EAST RIDGE SOLAR		SHAWBORO EAST RIDGE SOLAR	
AE1-072		DS		DS	
07 NOV 2025		CJM		CJM	
LATEST REVISION		DRAWN		DRAWN	
11		09/22/22		09/22/22	
10		30/16/22		EXISTING VEGETATION SUBSTITUTION NOTE	
9		04/22/22		UPDATED LAAYOUT	
8		02/02/21		UPDATED LAAYOUT AND REMOVED EXISTING VEGETATION SUBSTITUTION	
7		03/22/21		REMOVED EASTERN PROPERTY LINE	
6		10/17/20		UPDATED LAAYOUT	
5		03/05/21		PROPERTY CHANGES	
4		03/22/21		ADDED DETAILS PER COUNTY	
3		05/11/19		UPDTE LAAYOUT	
2		01/13/19		PROPERTY CHANGES	
1		03/08/18		PROPERTY CHANGES	
NO. DATE		DESCRIPTION		NO. DATE	
12		11/03/22		UPDATED ZONING SET	
11		10/12/22		UPDATED ZONING SET	
10		09/17/22		SHEET S/L2 PROPERTY INFORMATION	
9		09/17/22		UPDATED ACCESS PATHWAY TO REDUCE	
8		08/09/24		UPDATED LAAYOUT	
7		06/12/24		UPDATED SWITCHPANS AND SUBSTITUTION	
6		01/24/26		UPDATED LAAYOUT	
5		09/10/26		UPDATED ZONING SET	
4		10/07/26		UPDATED ZONING SET	
3		11/07/26		UPDATED ZONING SET	
2		11/07/26		UPDATED ZONING SET	
1		11/07/26		UPDATED ZONING SET	


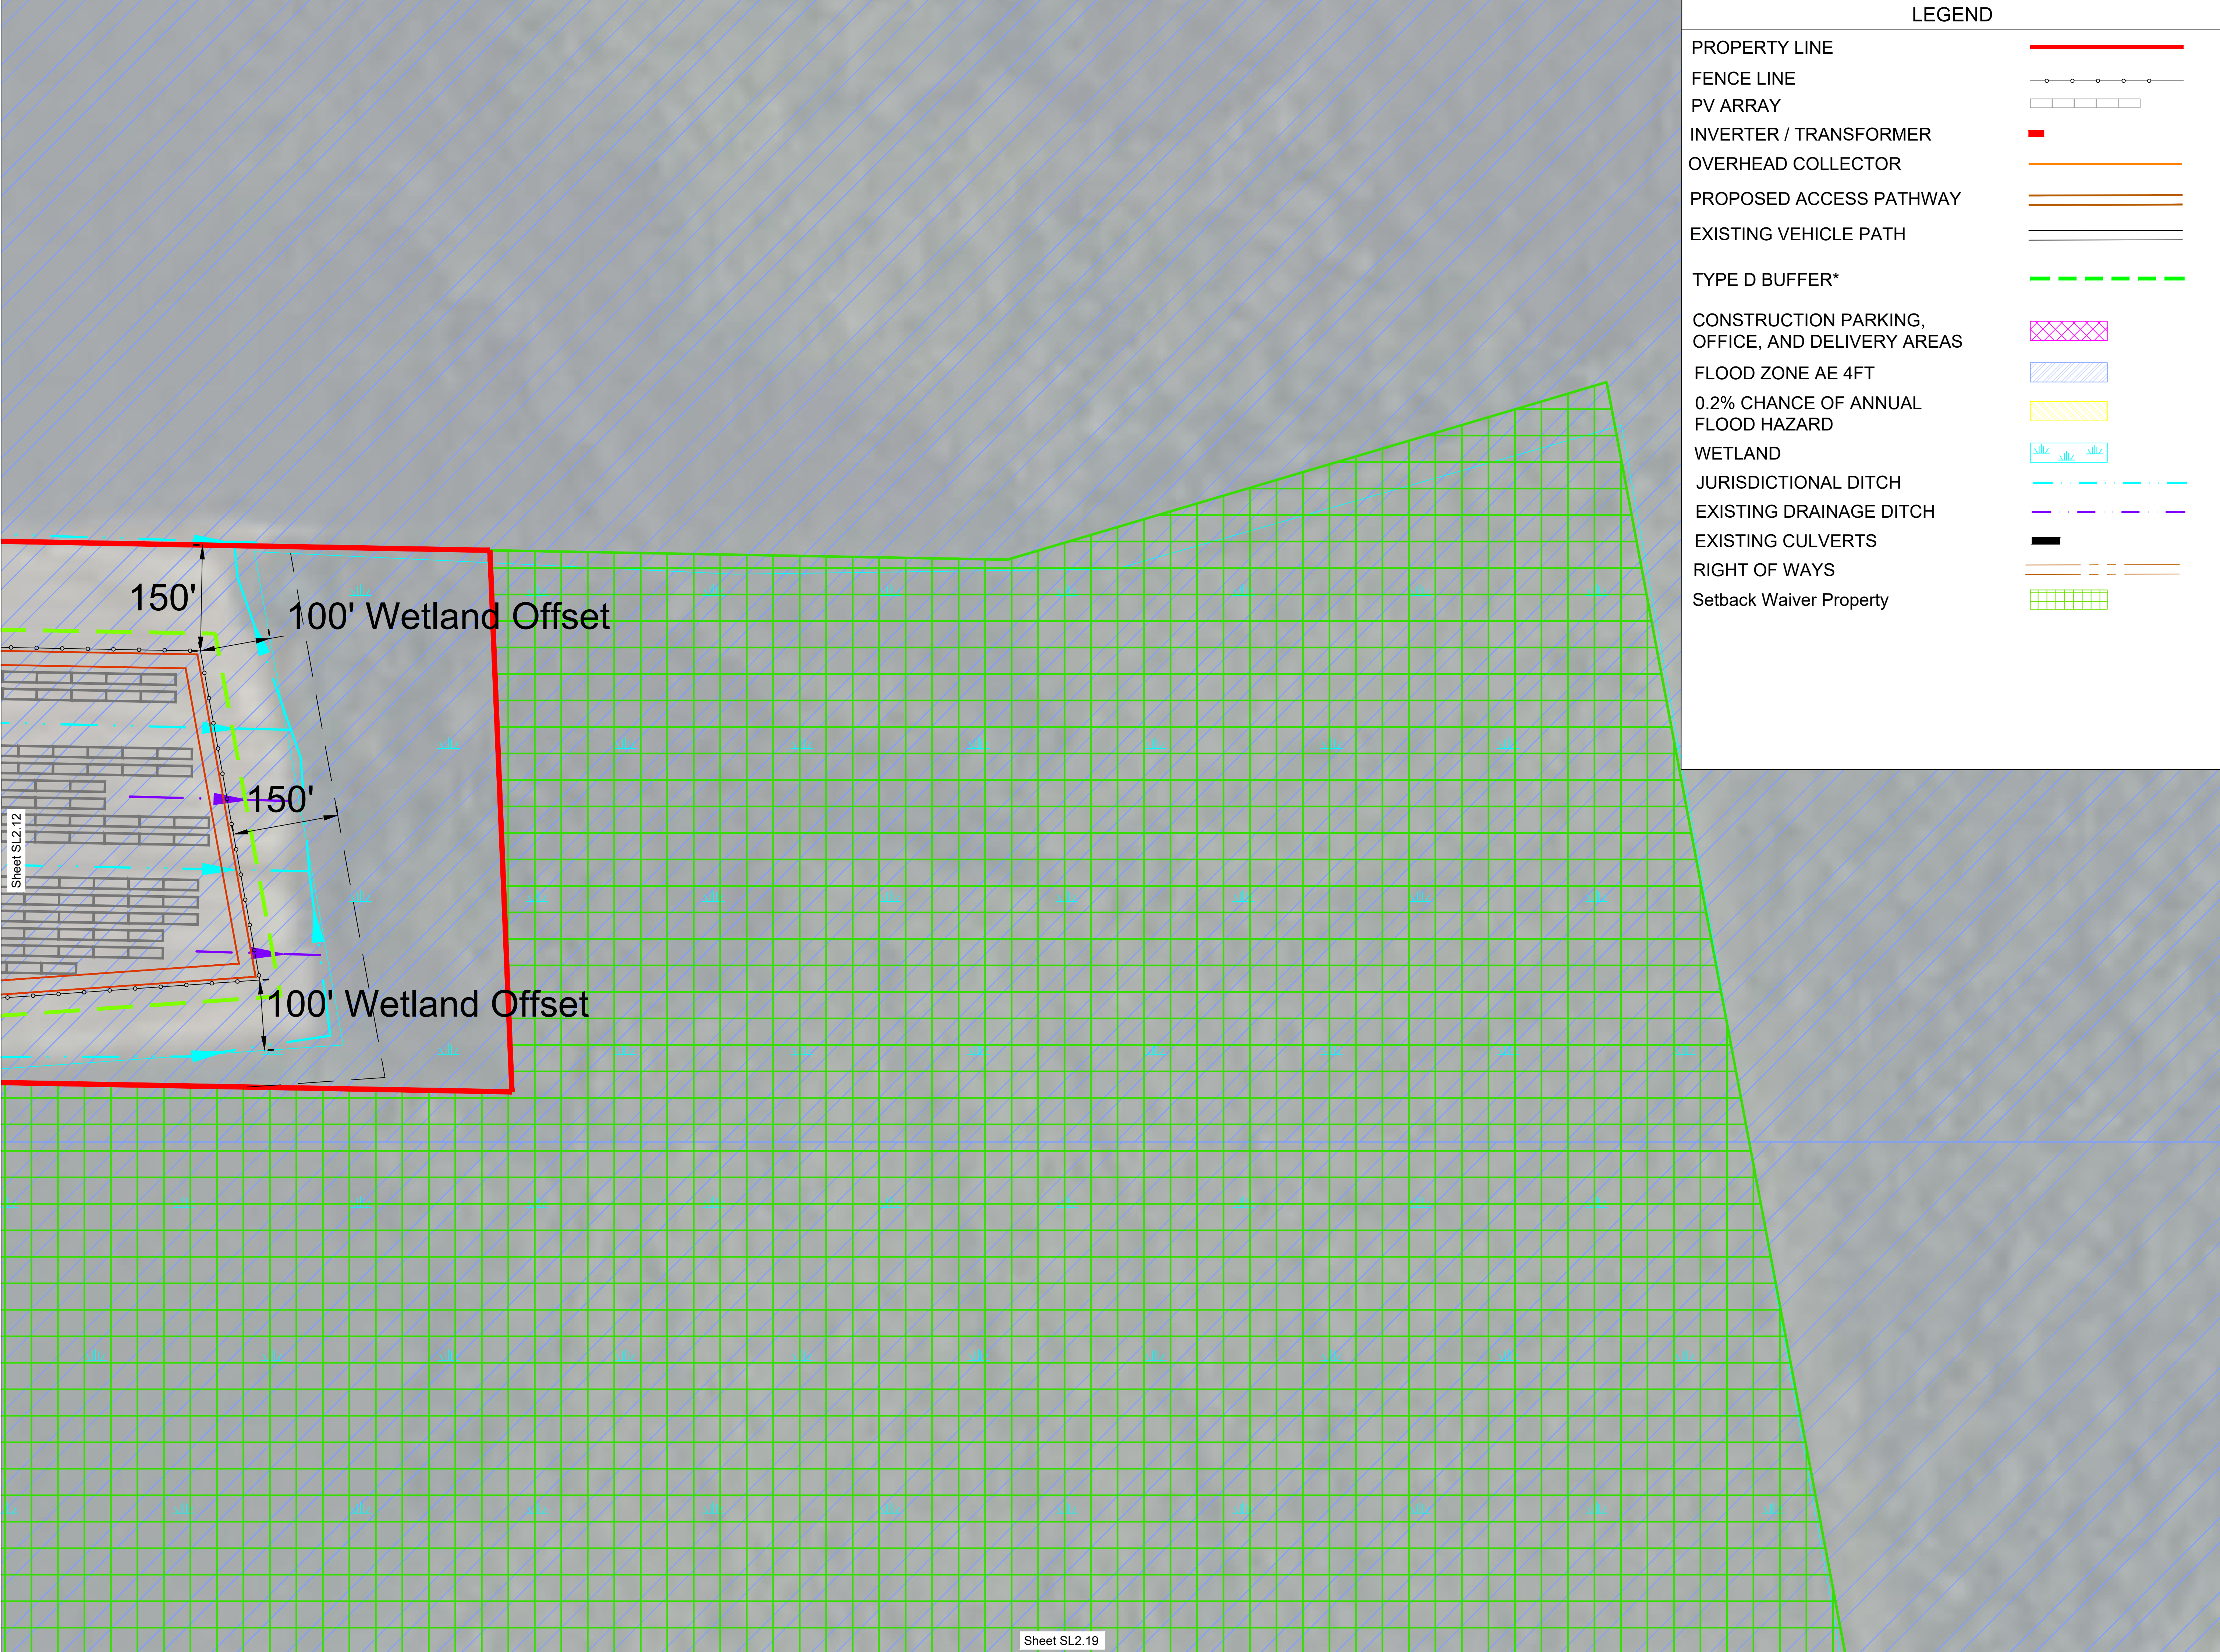



LEGEND	
PROPERTY LINE	
FENCE LINE	
PV ARRAY	
INVERTER / TRANSFORMER	
OVERHEAD COLLECTOR	
PROPOSED ACCESS PATHWAY	
EXISTING VEHICLE PATH	
TYPE D BUFFER*	
CONSTRUCTION PARKING, OFFICE, AND DELIVERY AREAS	
FLOOD ZONE AE 4FT	
0.2% CHANCE OF ANNUAL FLOOD HAZARD	
WETLAND	
JURISDICTIONAL DITCH	
EXISTING DRAINAGE DITCH	
EXISTING CULVERTS	
RIGHT OF WAYS	
Setback Waiver Property	

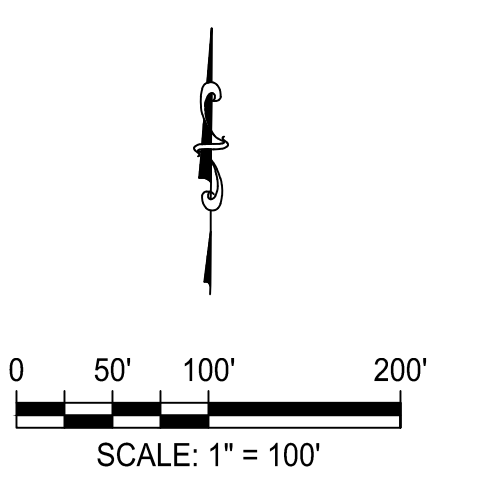

SUNENERGY1
595 Summer St, 4th Floor
Stamford, CT 06901
(203) 983-7875
www.SunEnergy1.com



SHAWBORO EAST RIDGE SOLAR PV POWER PLANT IN SHAWBORO, NORTH CAROLINA										
PROJECT NAME		DRAWING TITLE		JOB NO.		CHECKED		DATE		
AE1-072 DS DRAWN 07 NOV 2025 CJM		PROJECT OVERVIEW		SL2.13		12		11/03/24		UPDATED ZONING SET
						129		10/12/24		UPDATED ZONING SET SHEET NO. 10 PROPERTY INFORMATION
						13		09/17/23		UPDATED ACCESS PATHWAY TO REDUCE
						14		09/05/24		UPDATED LAYOUT
						15		06/19/24		UPDATED SWITCHYARD AND SUBSTATION
						16		01/24/25		UPDATED LAYOUT
						17		02/10/25		UPDATED LAYOUT
						18		10/07/25		UPDATED ZONING SET
						19		11/07/25		UPDATED ZONING SET
						20				
21										
22										
477										
47										

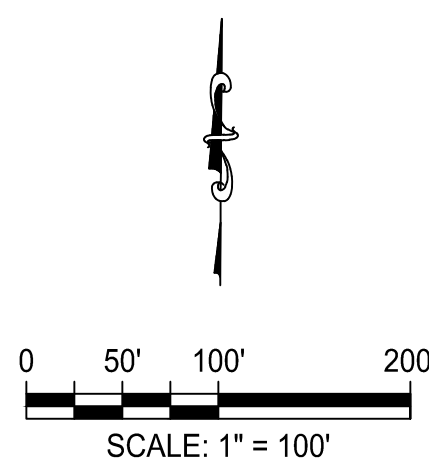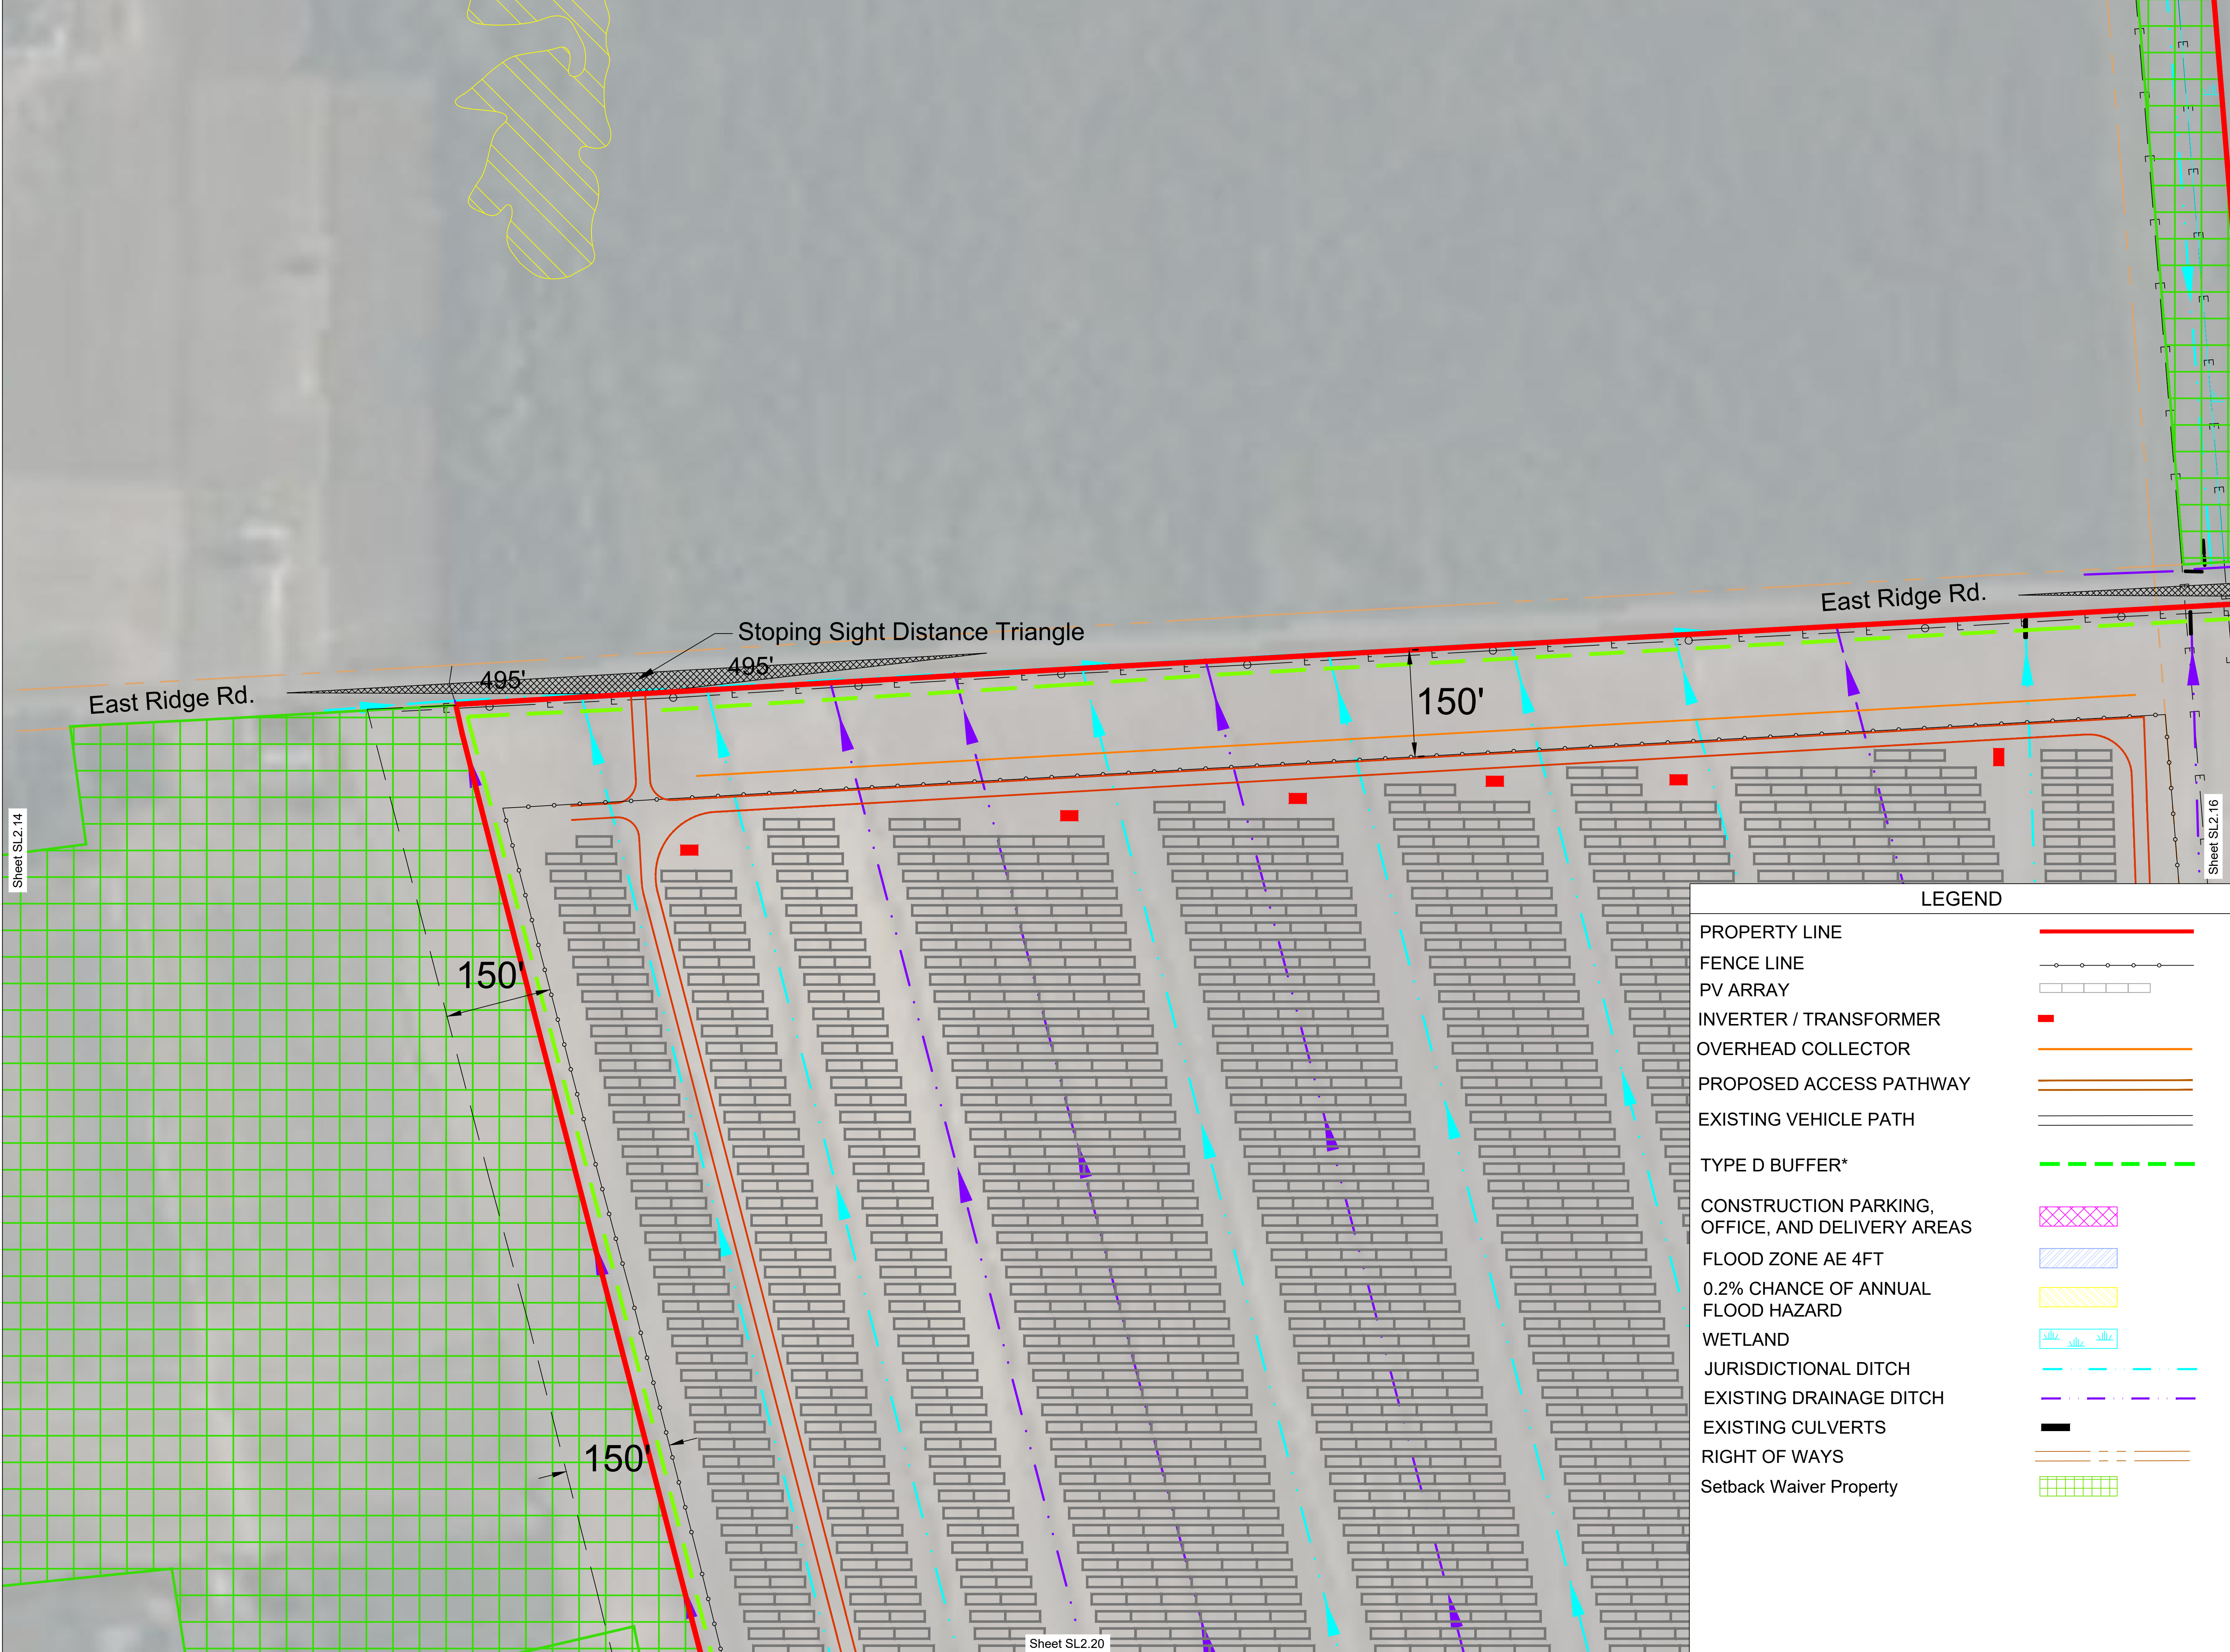

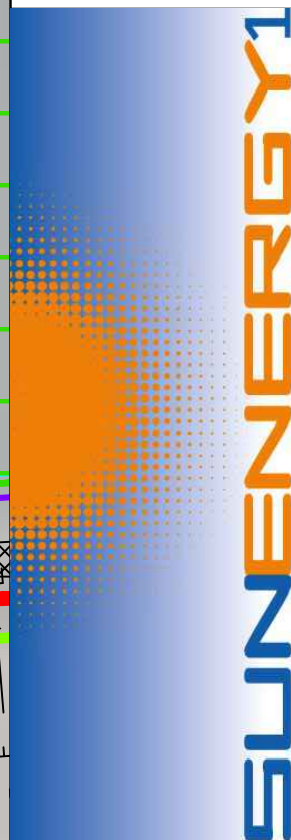

595 Summer St, 4th Floor
Stamford, CT 06901
(203) 983-7875
www.SunEnergy1.com

DRAWING NO.		PROJECT OVERVIEW		DRAWING TITLE	
SL2.15		SHAWBORO EAST RIDGE SOLAR		PROJECT NAME	
AE1-072		DS		JOB NO.	
07 NOV 2025		CJM		LATEST REVISION	

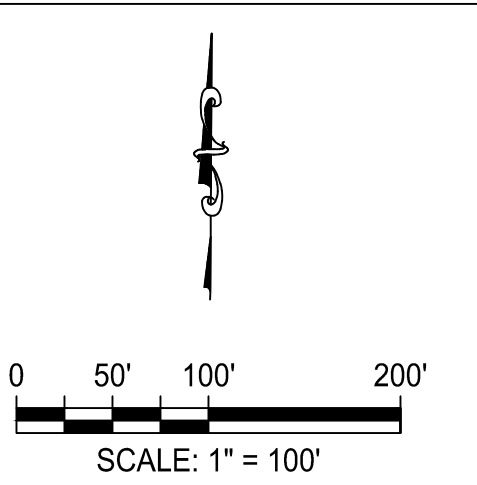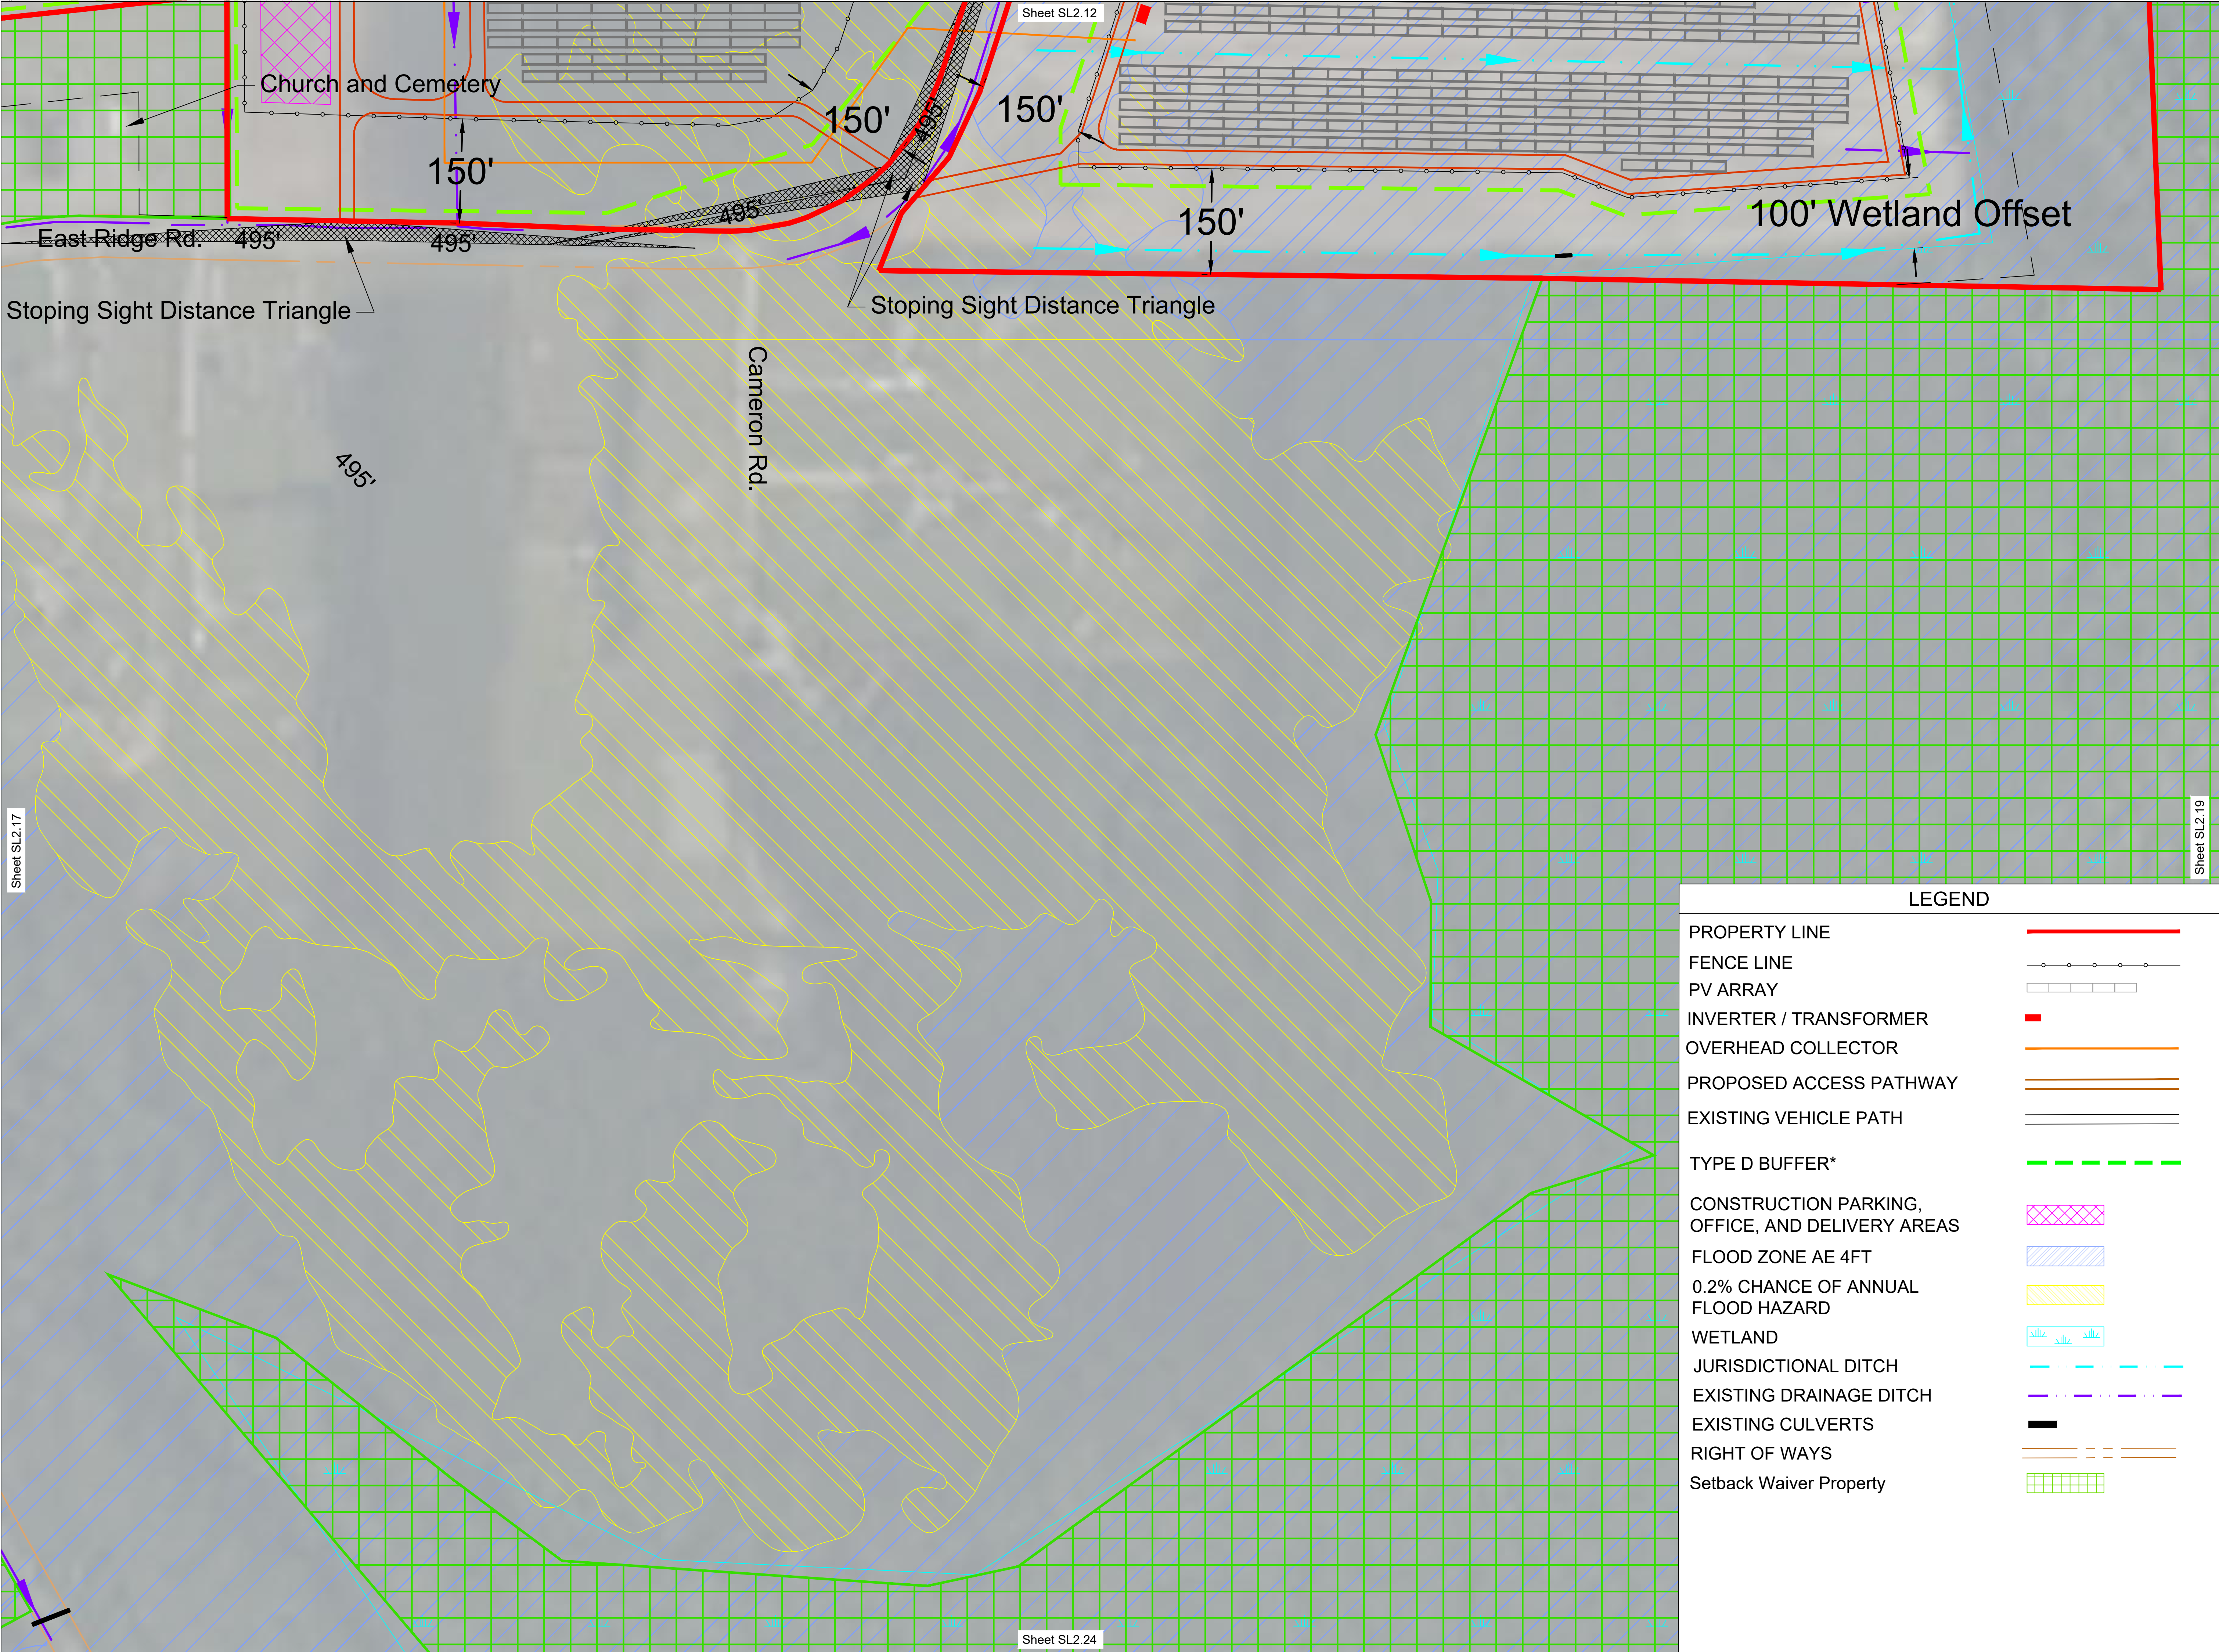




595 Summer St, 4th Floor
Stamford, CT 06901
(203) 983-7875
www.SunEnergy1.com

LEGEND	
PROPERTY LINE	
FENCE LINE	
PV ARRAY	
INVERTER / TRANSFORMER	
OVERHEAD COLLECTOR	
PROPOSED ACCESS PATHWAY	
EXISTING VEHICLE PATH	
TYPE D BUFFER*	
CONSTRUCTION PARKING, OFFICE, AND DELIVERY AREAS	
FLOOD ZONE AE 4FT	
0.2% CHANCE OF ANNUAL FLOOD HAZARD	
WETLAND	
JURISDICTIONAL DITCH	
EXISTING DRAINAGE DITCH	
EXISTING CULVERTS	
RIGHT OF WAYS	
Setback Waiver Property	

DRAWING NO.						SL2.18					
PROJECT OVERVIEW						PROJECT TITLE					
AE1-072						CHECKED					
						DS					
						DRAWN					
LATEST REVISION						07 NOV 2025					
CJM						EXISTING VEGETATION SUBSTITUTION					
						NOTE					
						UPDATED ZONING SET					
11						09/22/24					
JOB NO.						12					
NO.						DATE					
DESCRIPTION						12					
1						11/03/24					
2						10A					
3						12A					
4						13					
5						14					
6						15					
7						16					
8						17					
9						18					
10						19					
11						20					



Sheet SL2.14

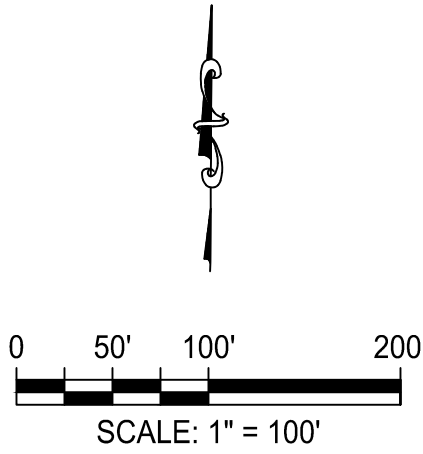





SUNENERGY1
595 Summer St, 4th Floor
Stamford, CT 06901
(203) 983-7875
www.SunEnergy1.com

LEGEND	
PROPERTY LINE	
FENCE LINE	
PV ARRAY	
INVERTER / TRANSFORMER	
OVERHEAD COLLECTOR	
PROPOSED ACCESS PATHWAY	
EXISTING VEHICLE PATH	
TYPE D BUFFER*	
CONSTRUCTION PARKING, OFFICE, AND DELIVERY AREAS	
FLOOD ZONE AE 4FT	
0.2% CHANCE OF ANNUAL FLOOD HAZARD	
WETLAND	
JURISDICTIONAL DITCH	
EXISTING DRAINAGE DITCH	
EXISTING CULVERTS	
RIGHT OF WAYS	
Setback Waiver Property	

Sheet SL2.21		12	11/03/24	UPDATED ZONING SET
SHAWBORO EAST		12A	01/24/24	UPDATED ZONING SET
RIDGE SOLAR		13	05/17/23	UPDATED ACCESS PATHWAY TO REDUCE
PV POWER PLANT		14	02/05/24	UPDATED LAYOUT
IN SHAWBORO, NORTH CAROLINA		15	06/12/24	UPDATED SWITCHYARD AND SUBSTATION
PROJECT NAME		16	01/24/25	UPDATED LAYOUT
JOB NO.		17	02/10/24	UPDATED LAYOUT
CHECKED		18	01/07/24	UPDATED ZONING SET
DRAWN		19	01/07/24	UPDATED ZONING SET
DS				
CJM				
07 NOV 2025				
PROJECT OVERVIEW				
SL2.20				

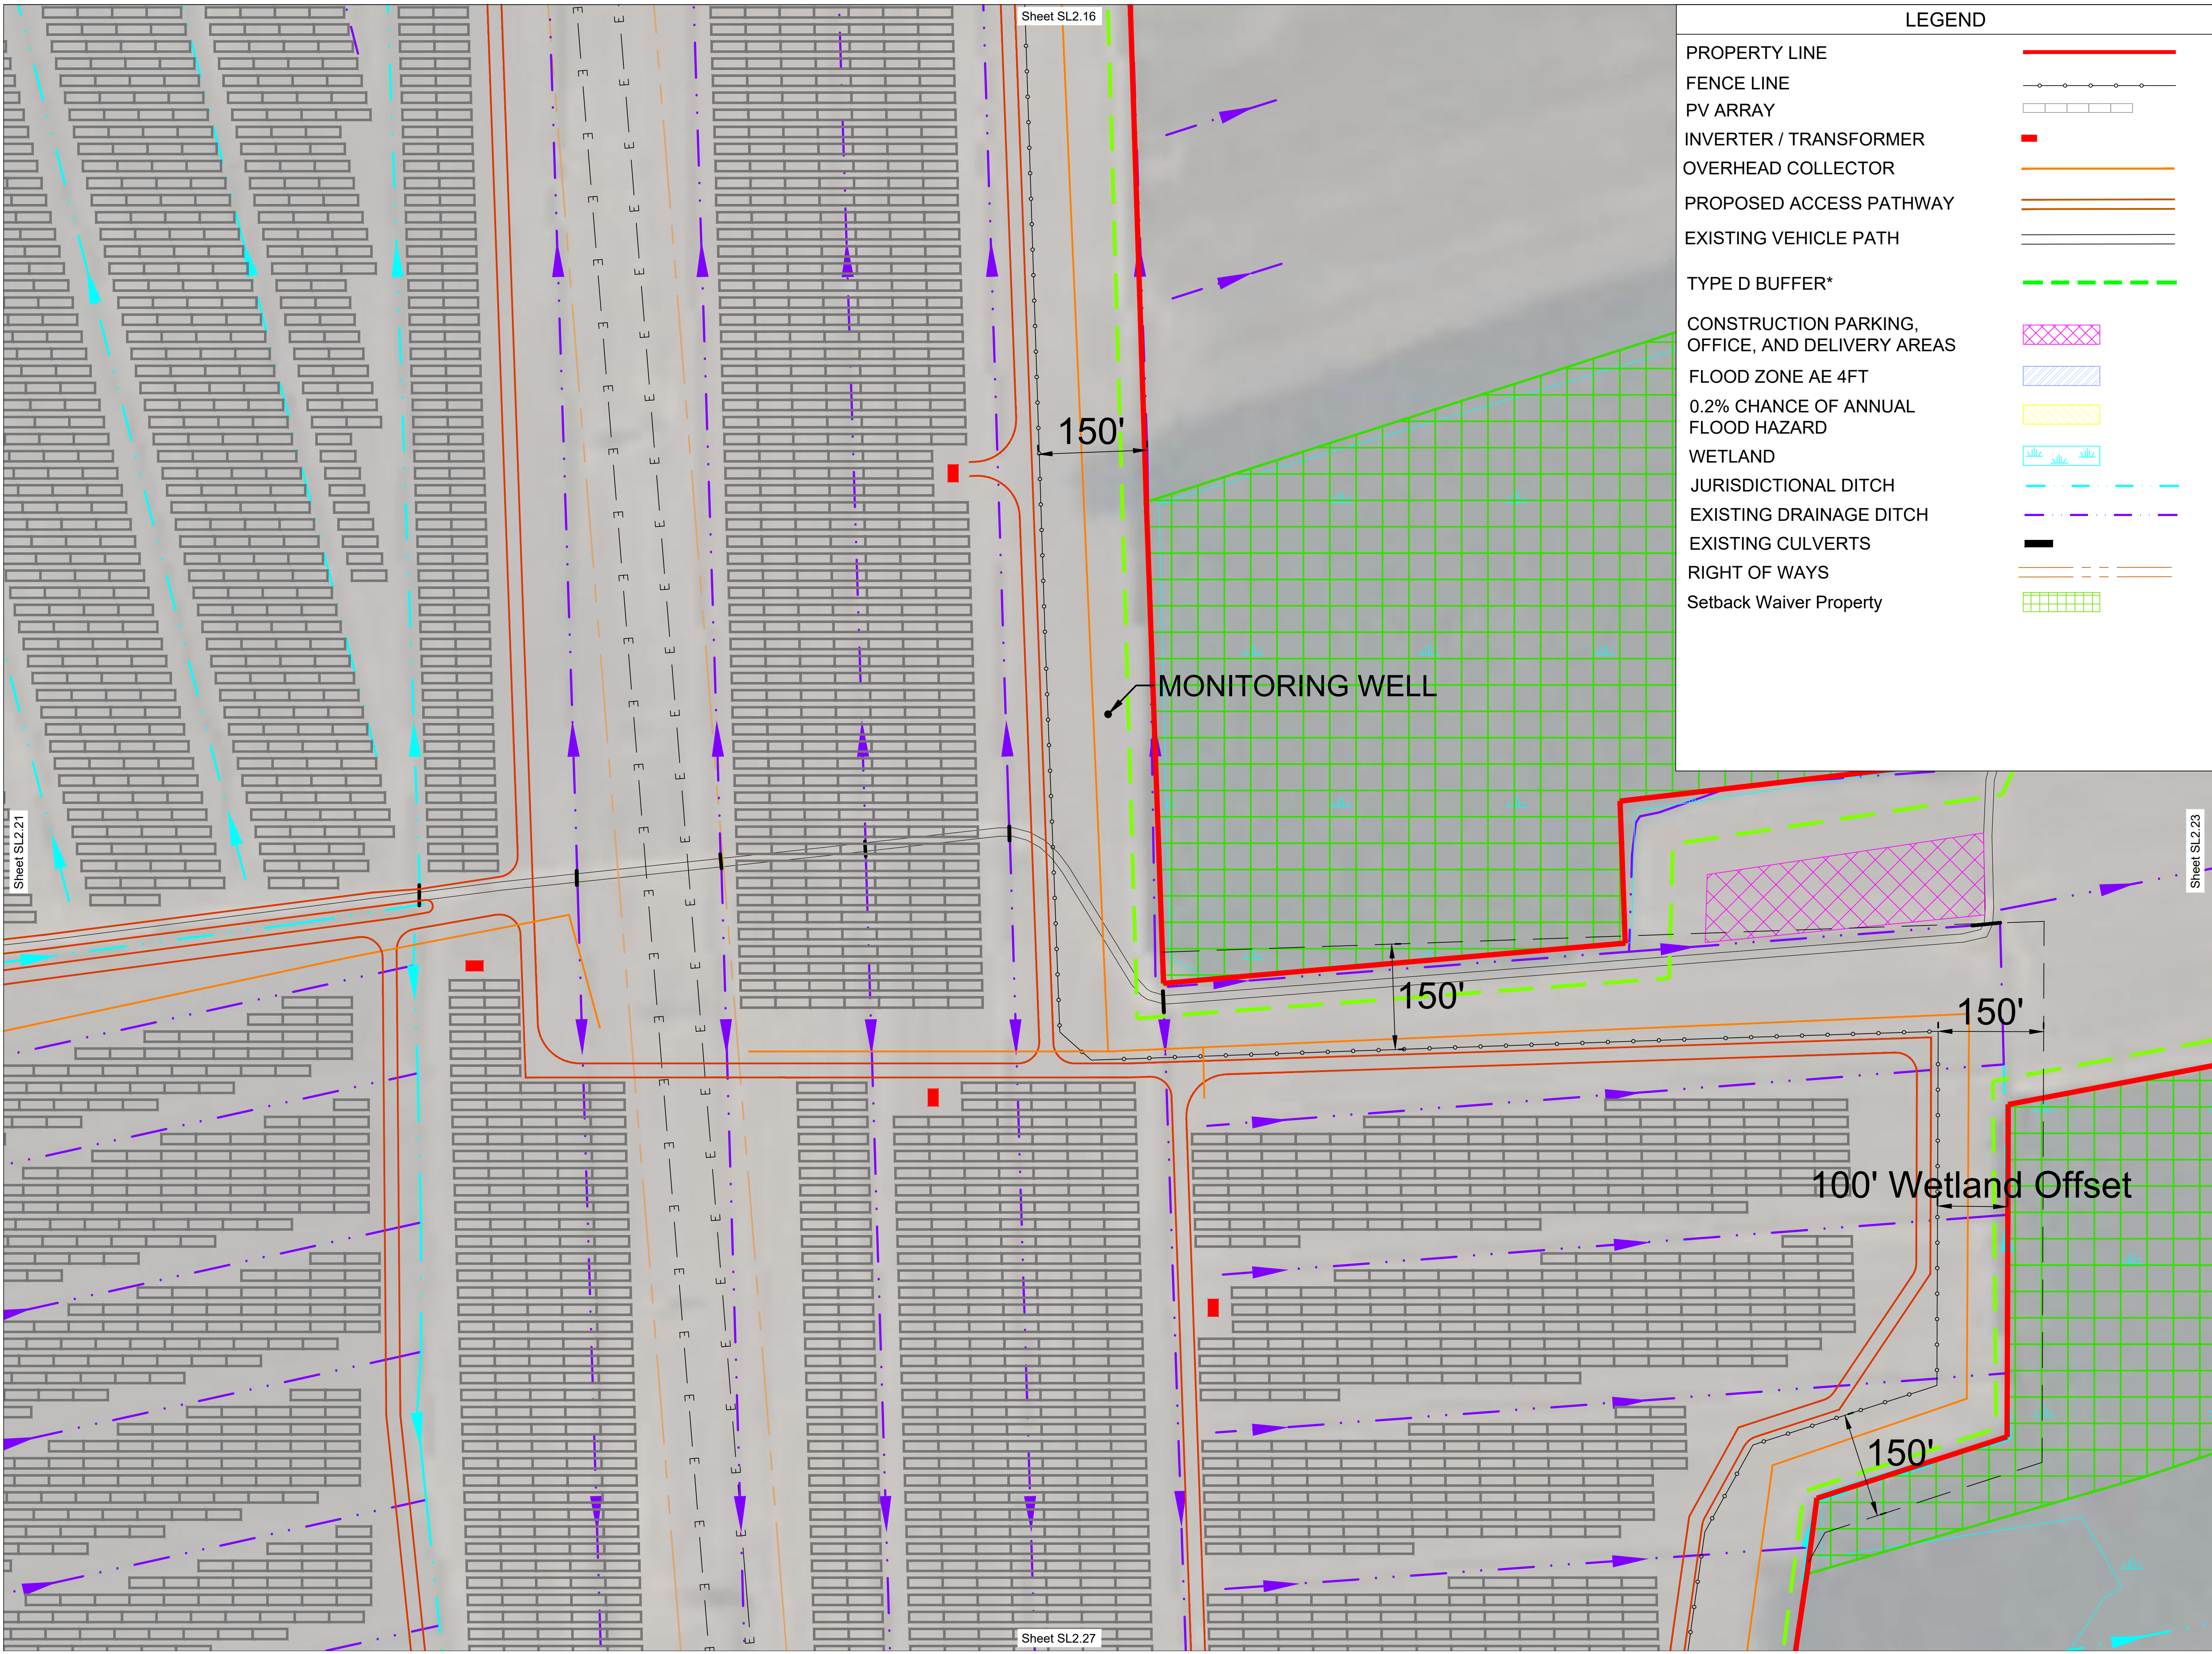



LEGEND	
PROPERTY LINE	
FENCE LINE	
PV ARRAY	
INVERTER / TRANSFORMER	
OVERHEAD COLLECTOR	
PROPOSED ACCESS PATHWAY	
EXISTING VEHICLE PATH	
TYPE D BUFFER*	
CONSTRUCTION PARKING, OFFICE, AND DELIVERY AREAS	
FLOOD ZONE AE 4FT	
0.2% CHANCE OF ANNUAL FLOOD HAZARD	
WETLAND	
JURISDICTIONAL DITCH	
EXISTING DRAINAGE DITCH	
EXISTING CULVERTS	
RIGHT OF WAYS	
Setback Waiver Property	

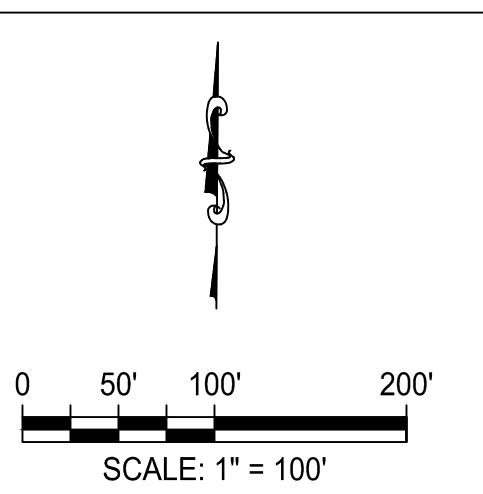



595 Summer St, 4th Floor
Stamford, CT 06901
(203) 983-7875
www.SunEnergy1.com



PROJECT NAME SHAWBORO EAST RIDGE SOLAR PV POWER PLANT IN SHAWBORO, NORTH CAROLINA	JOB NO. AE1-072	CHECKED DS	DRAWN CJM	LATEST REVISION 07 NOV 2025	DRAWING TITLE PROJECT OVERVIEW	DRAWING NO. SL2.22	12	11/03/24	UPDATED ZONING SET
							12A	01/26/25	UPDATED ZONING SET
							13	08/17/25	UPDATED ACCESS PATHWAY TO REDUCE
							14	08/05/24	UPDATED LAYOUT
							15	08/02/24	UPDATED SWITCHYARD AND SUBSTATION
							16	01/24/25	UPDATED LAYOUT
							17	02/10/25	UPDATED ZONING SET
							18	10/07/25	UPDATED ZONING SET
							19	11/07/25	UPDATED ZONING SET
							20	08/16/25	EXISTING VEGETATION SUBSTITUTION
							21	08/22/25	UPDATED ZONING SET

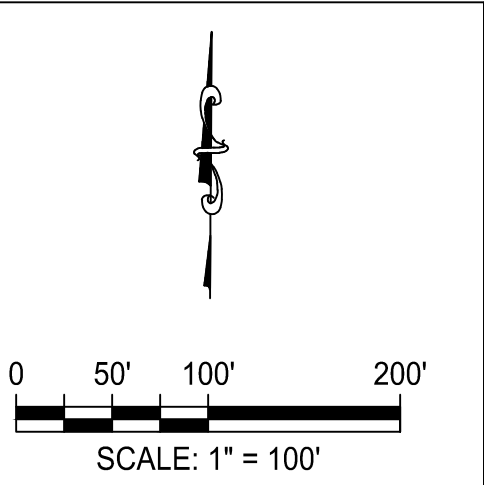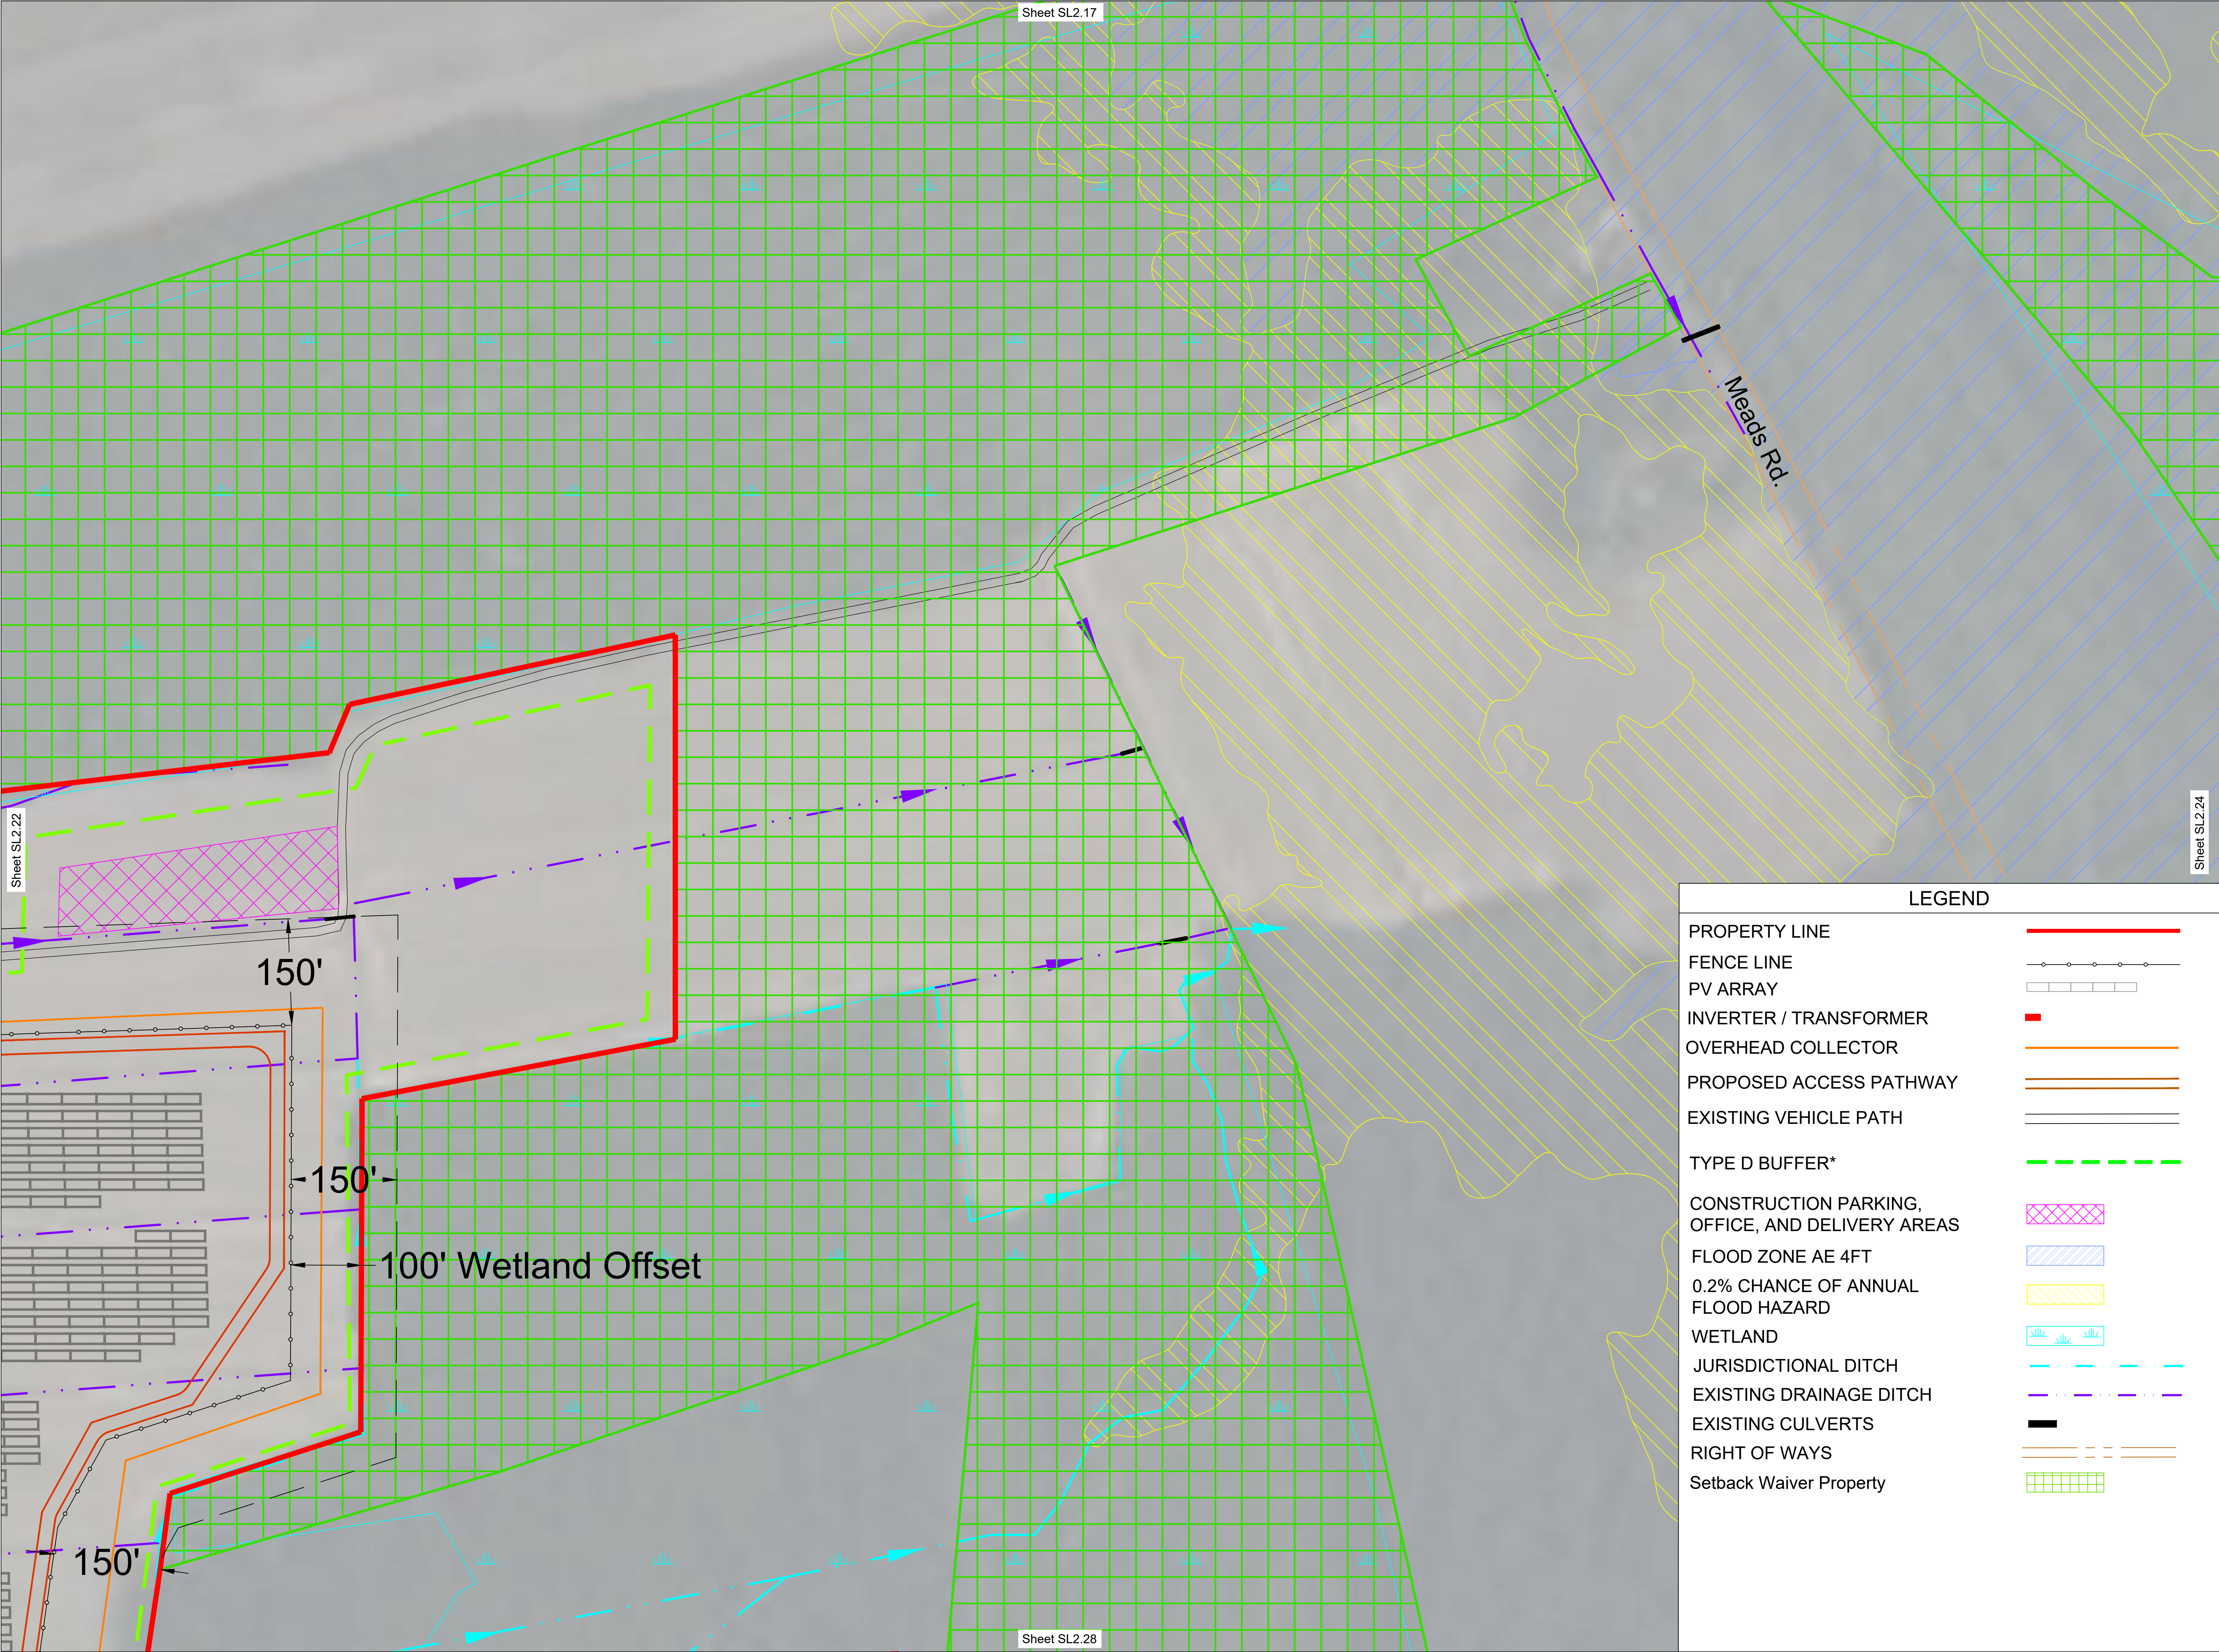

SUNENERGY1
595 Summer St, 4th Floor
Stamford, CT 06901
(203) 983-7875
www.SunEnergy1.com

LEGEND	
PROPERTY LINE	
FENCE LINE	
PV ARRAY	
INVERTER / TRANSFORMER	
OVERHEAD COLLECTOR	
PROPOSED ACCESS PATHWAY	
EXISTING VEHICLE PATH	
TYPE D BUFFER*	
CONSTRUCTION PARKING, OFFICE, AND DELIVERY AREAS	
FLOOD ZONE AE 4FT	
0.2% CHANCE OF ANNUAL FLOOD HAZARD	
WETLAND	
JURISDICTIONAL DITCH	
EXISTING DRAINAGE DITCH	
EXISTING CULVERTS	
RIGHT OF WAYS	
Setback Waiver Property	

PROJECT NAME SHAWBORO EAST RIDGE SOLAR PV POWER PLANT IN SHAWBORO, NORTH CAROLINA JOB NO. AE1-072 LATEST REVISION 07 NOV 2025	DRAWING TITLE PROJECT OVERVIEW DRAWING NO. SL2.23	NO.	DATE	DESCRIPTION	NO.	DATE	DESCRIPTION
		1	03/01/18	PROPERTY CHANGES	12	11/03/21	UPDATED ZONING SET
		2	01/13/19	PROPERTY CHANGES	13	01/26/21	UPDATED ZONING SET
		3	06/11/19	UPDATE LAYOUT	14	02/05/21	UPDATED ACCESS PATHWAY TO REDUCE
		4	03/03/21	ADDED DETAILS PER COUNTY	15	06/10/21	UPDATED LAYOUT
		5	03/05/21	PROPERTY CHANGES	16	01/24/22	UPDATED LAYOUT
		6	03/11/21	UPDATED LAYOUT	17	02/10/22	UPDATED LAYOUT
		7	03/22/21	REMOVED EASTERN PROPERTY	18	10/07/22	UPDATED ZONING SET
		8	06/09/21	UPDATED LAYOUT AND REMOVED	19	11/01/22	UPDATED ZONING SET
		9	04/22/22	EXISTING VEHICLE PATH SUBSTITUTION			
		10	04/14/22	EXISTING VEHICLE PATH SUBSTITUTION			
		11	09/22/22	UPDATED ZONING SET			

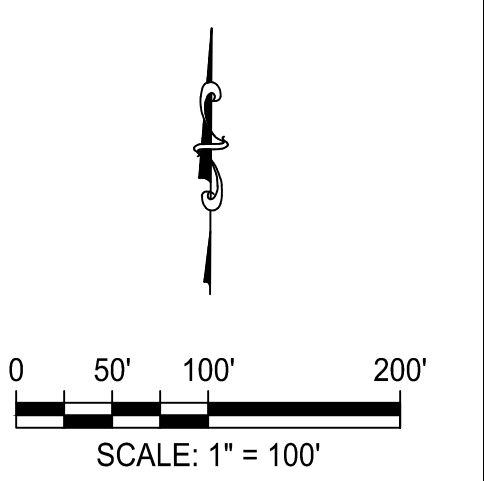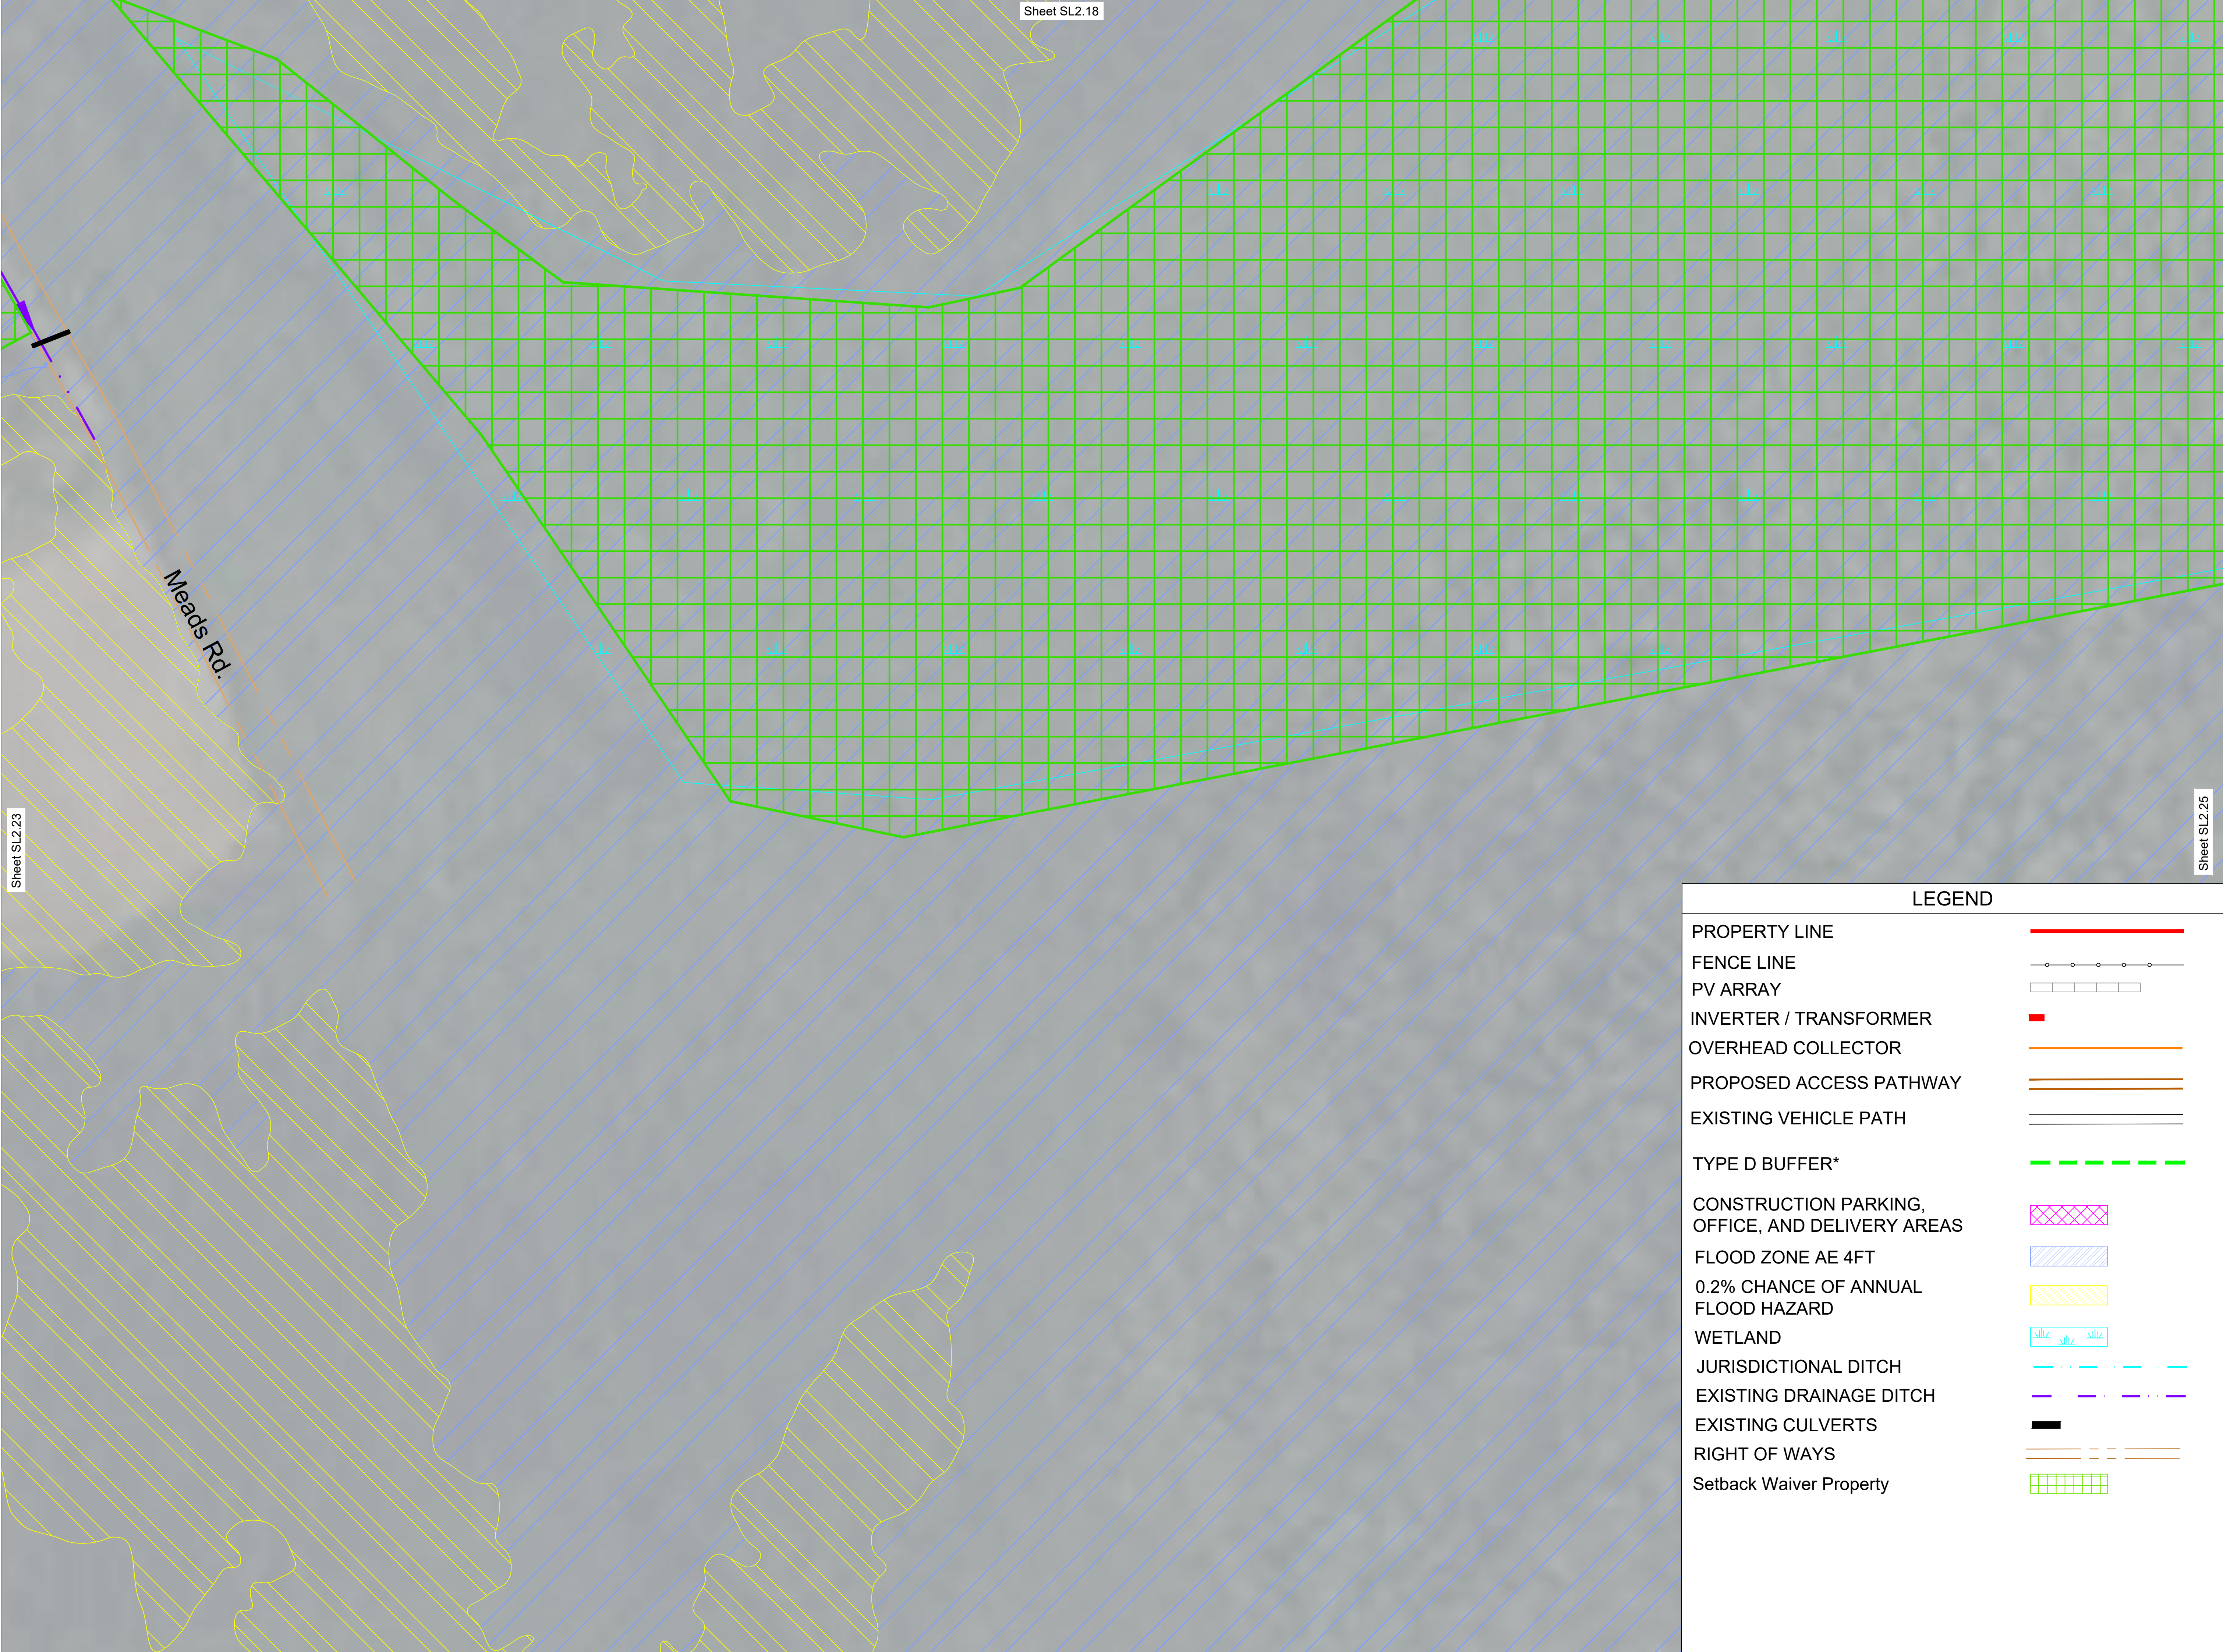




595 Summer St, 4th Floor
Stamford, CT 06901
(203) 983-7875
www.SunEnergy1.com

LEGEND		
PROPERTY LINE		
FENCE LINE		
PV ARRAY		
INVERTER / TRANSFORMER		
OVERHEAD COLLECTOR		
PROPOSED ACCESS PATHWAY		
EXISTING VEHICLE PATH		
TYPE D BUFFER*		
CONSTRUCTION PARKING, OFFICE, AND DELIVERY AREAS		
FLOOD ZONE AE 4FT		
0.2% CHANCE OF ANNUAL FLOOD HAZARD		
WETLAND		
JURISDICTIONAL DITCH		
EXISTING DRAINAGE DITCH		
EXISTING CULVERTS		
RIGHT OF WAYS		
Setback Waiver Property		

PROJECT NAME SHAWBORO EAST RIDGE SOLAR PV POWER PLANT IN SHAWBORO, NORTH CAROLINA JOB NO. LATEST REVISION 07 NOV 2025	DRAWING TITLE PROJECT OVERVIEW DRAWING NO. SL2.24	NO.	DATE	DESCRIPTION	12	11/03/24	UPDATED ZONING SET
		1	03/08/18	PROPERTY CHANGES	12A	01/28/23	UPDATED ZONING SET SHEET S.L.10 PROPERTY INFORMATION
		2	01/31/18	PROPERTY CHANGES	13	05/17/23	UPDATED ACCESS PATHWAY TO REDUCE
		3	06/31/18	UPDATE LAYOUT	14	02/05/24	UPDATED LAYOUT
		4	03/03/21	ADDED DETAILS PER COUNTY	15	06/12/24	UPDATED SWITCHYARD AND SUBSTATION
		5	03/05/21	PROPERTY CHANGES	16	01/24/25	UPDATED LAYOUT
		6	03/11/21	UPDATED LAYOUT	17	02/10/25	UPDATED LAYOUT
		7	03/22/21	REMOVED EASTERN PROPERTY	18	01/07/25	UPDATED ZONING SET
		8	06/01/21	UPDATED LAYOUT AND REMOVED PROPERTY ON INDIANTOWN RD	19		
		9	04/22/22	EXISTING VEGETATION SUBSTITUTION			
		10	04/14/22				
		11	09/22/22	UPDATED ZONING SET			


[illegible]

DRAWING TITLE	PROJECT OVERVIEW
DRAWING NO.	SL2.29

 LEGEND	
PROPERTY LINE	
FENCE LINE	
PV ARRAY	
INVERTER / TRANSFORMER	
OVERHEAD COLLECTOR	
PROPOSED ACCESS PATHWAY	
EXISTING VEHICLE PATH	
TYPE D BUFFER*	
CONSTRUCTION PARKING, OFFICE, AND DELIVERY AREAS	
FLOOD ZONE AE 4FT	
0.2% CHANCE OF ANNUAL FLOOD HAZARD	
WETLAND	
JURISDICTIONAL DITCH	
EXISTING DRAINAGE DITCH	
EXISTING CULVERTS	
RIGHT OF WAYS	
Setback Waiver Property	



LEGEND		
PROPERTY LINE		
FENCE LINE		
PV ARRAY		
INVERTER / TRANSFORMER		
OVERHEAD COLLECTOR		
PROPOSED ACCESS PATHWAY		
EXISTING VEHICLE PATH		
TYPE D BUFFER*		
CONSTRUCTION PARKING, OFFICE, AND DELIVERY AREAS		
FLOOD ZONE AE 4FT		
0.2% CHANCE OF ANNUAL FLOOD HAZARD		
WETLAND		
JURISDICTIONAL DITCH		
EXISTING DRAINAGE DITCH		
EXISTING CULVERTS		
RIGHT OF WAYS		
Setback Waiver Property		

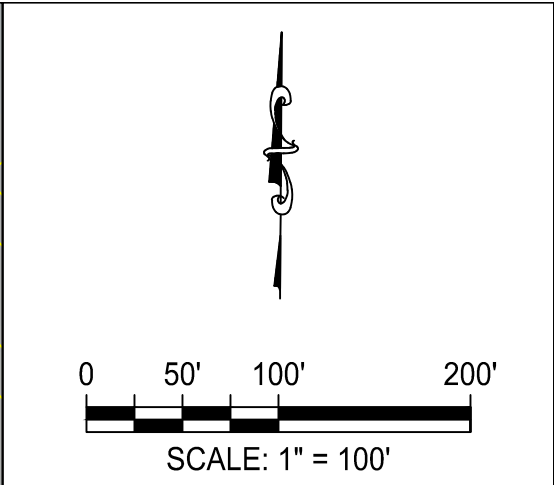



595 Summer St, 4th Floor
Stamford, CT 06901
(203) 983-7875
www.SunEnergy1.com

PROJECT NAME	DRAWING TITLE	DRAWING NO.
SHAWBORO EAST RIDGE SOLAR PV POWER PLANT IN SHAWBORO, NORTH CAROLINA	PROJECT OVERVIEW	SL2.32
PROJECT NO.	AE1-072	07 NOV 2025
DESIGNER	DS	
DRAWN	CJM	
CHECKED		
DATE		
NO.	DESCRIPTION	DATE
1	03/08/18 PROPERTY CHANGES	12/11/2024 UPDATED ZONING SET
2	01/31/18 PROPERTY CHANGES	12/04/24 UPDATED ZONING SET
3	06/31/18 UPDATE LAYOUT	08/17/23 UPDATED ACCESS PATHWAY TO REDUCE
4	08/02/21 ADDED DETAILS PER COUNTY	08/05/24 UPDATED LAYOUT
5	08/05/21 PROPERTY CHANGES	08/05/24 UPDATED SWITCHYARD AND SUBSTATION
6	08/17/21 REMOVED EASTERN PROPERTY	08/05/24 UPDATED LAYOUT
7	08/22/21 REMOVED EASTERN PROPERTY	08/05/24 UPDATED ZONING SET
8	08/02/21 ADDED DETAILS PER COUNTY	08/05/24 UPDATED ZONING SET
9	08/22/21 REMOVED EASTERN PROPERTY	08/05/24 UPDATED ZONING SET
10	08/22/21 EXISTING VEGETATION SUBSTITUTION	08/05/24 UPDATED ZONING SET
11	08/22/21 EXISTING VEGETATION SUBSTITUTION	08/05/24 UPDATED ZONING SET

